



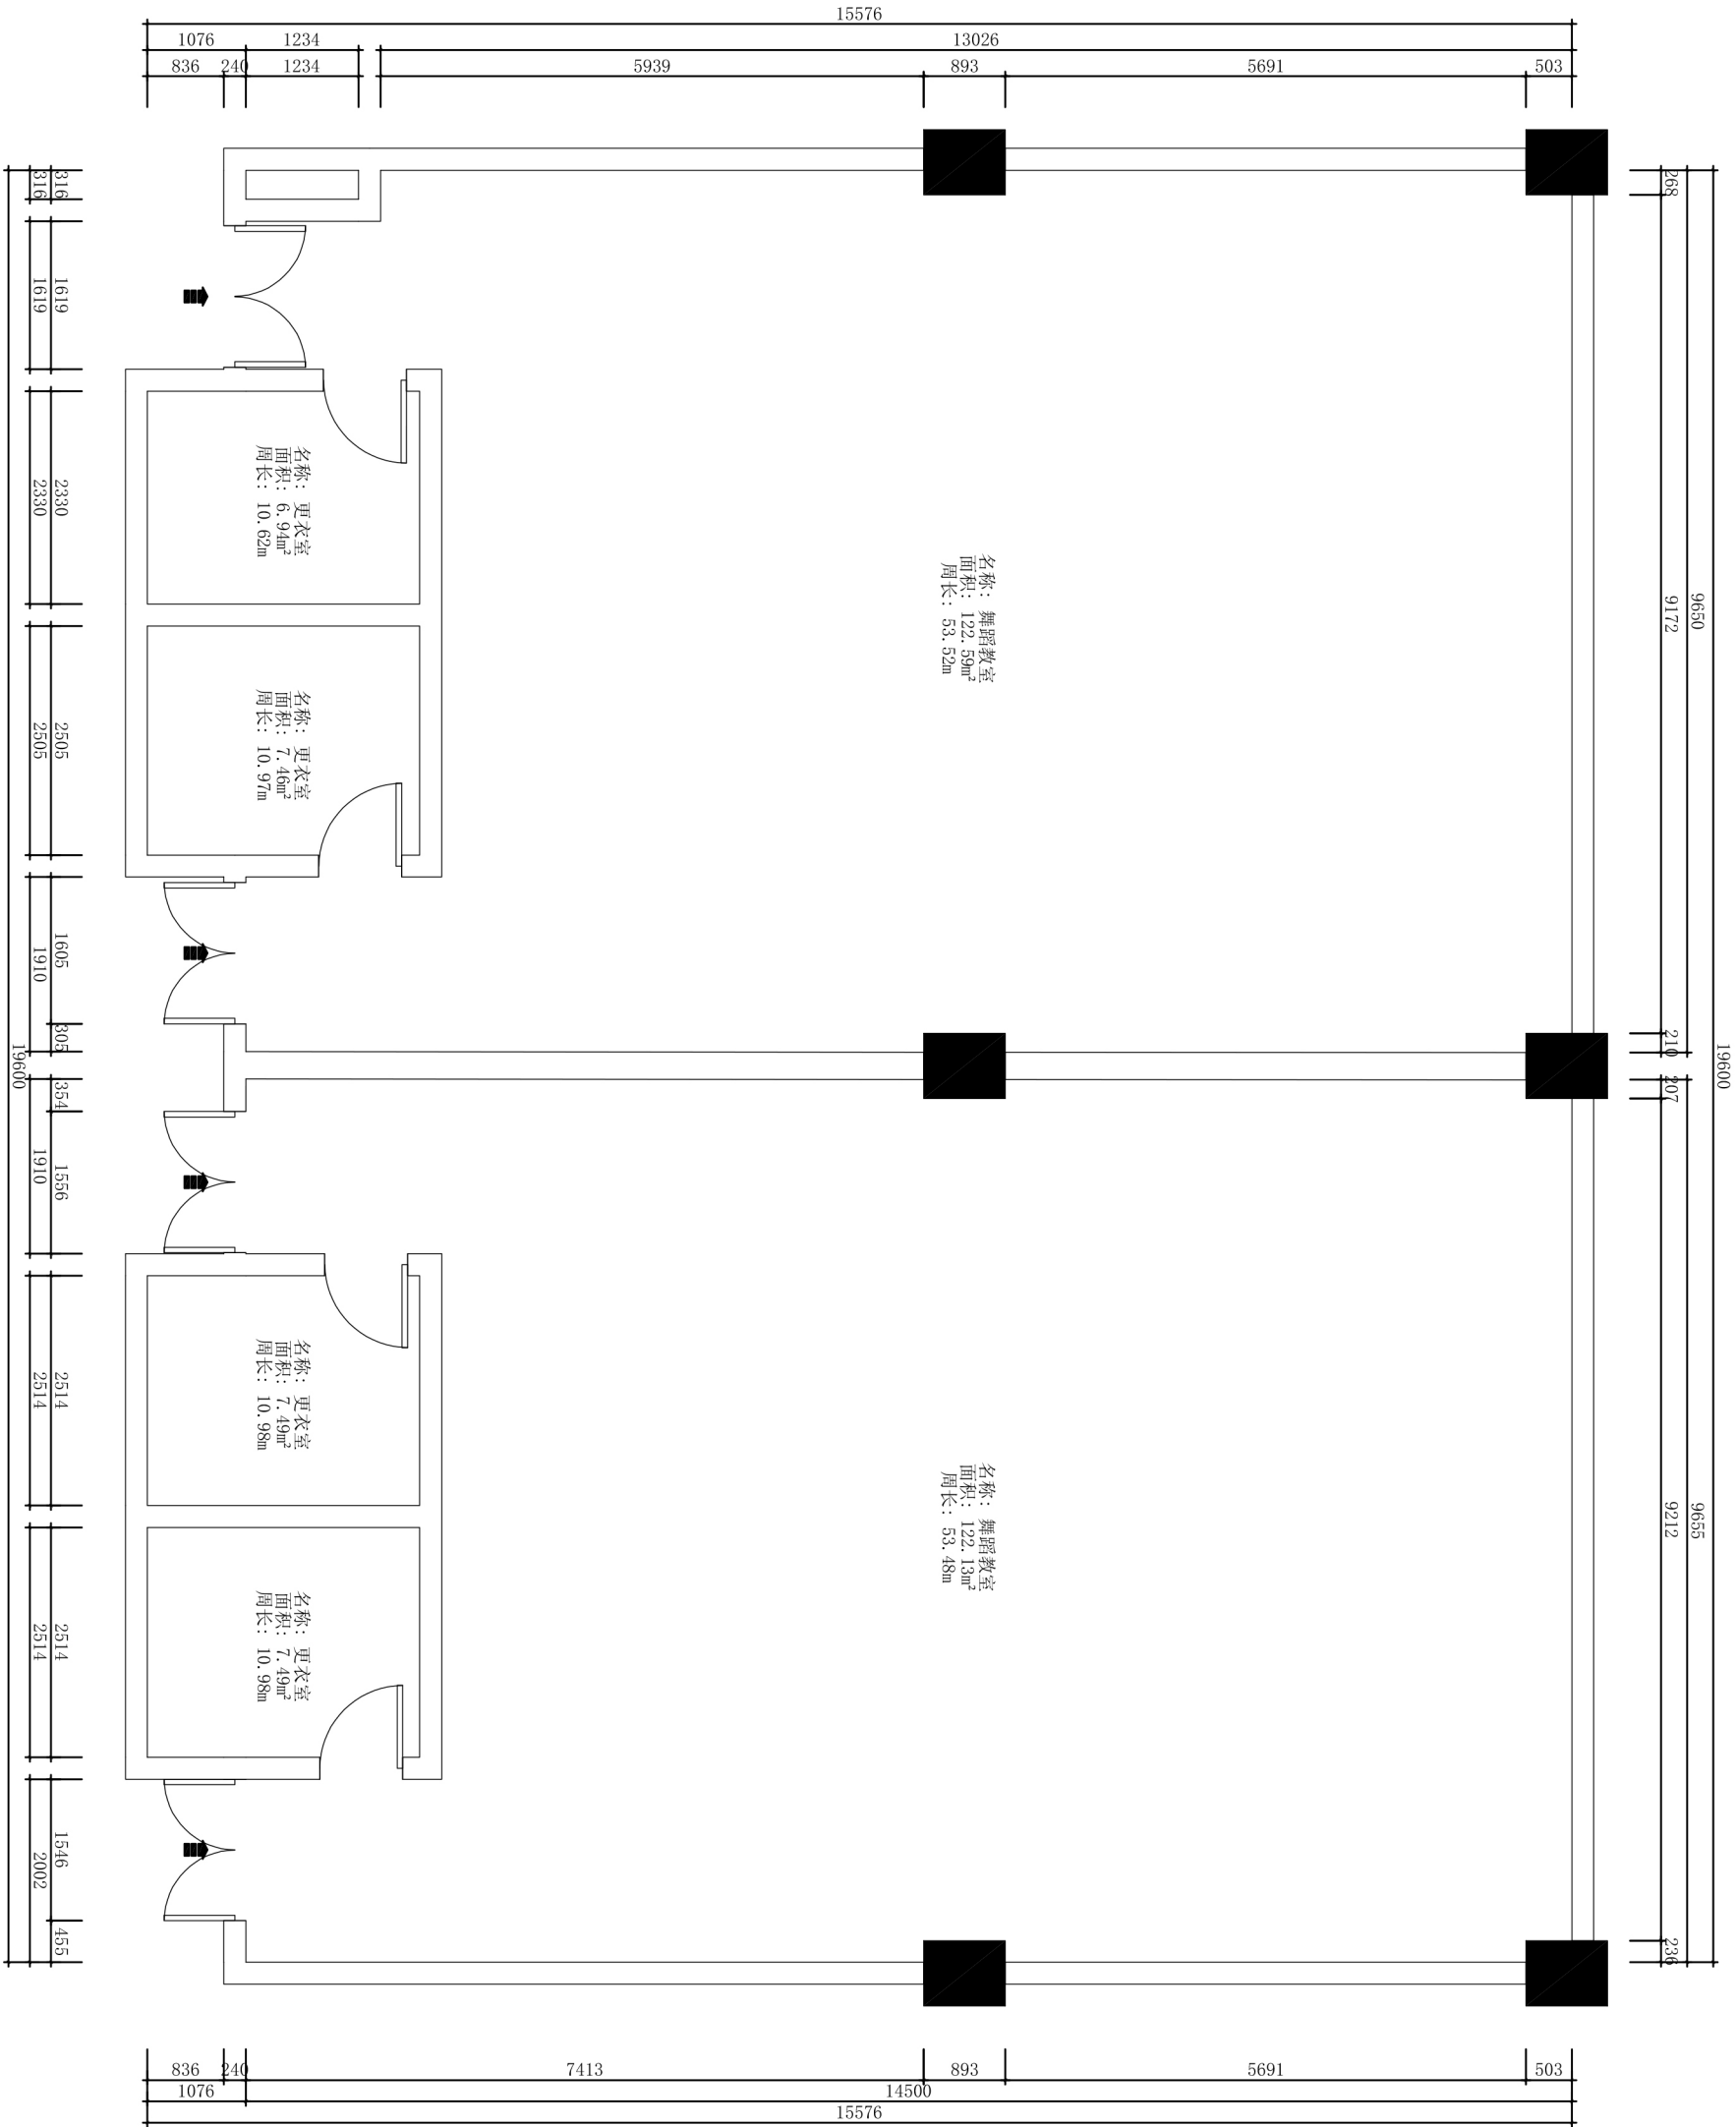


原始户型图

工程名称: PROJECT:	
图纸名称: TITLE:	
设计总监: DESIGNER IN CHIEF:	
签名: SIGNATURE:	
项目负责人: PROJECT IN CHIEF:	
签名: SIGNATURE:	
设计师: DESIGNER:	
审核: APPROVED BY:	
业主签名: CLIENT SIGNATURE:	
图纸编号: DRAWING NO:	
比例: SCALE:	日期: DATE:

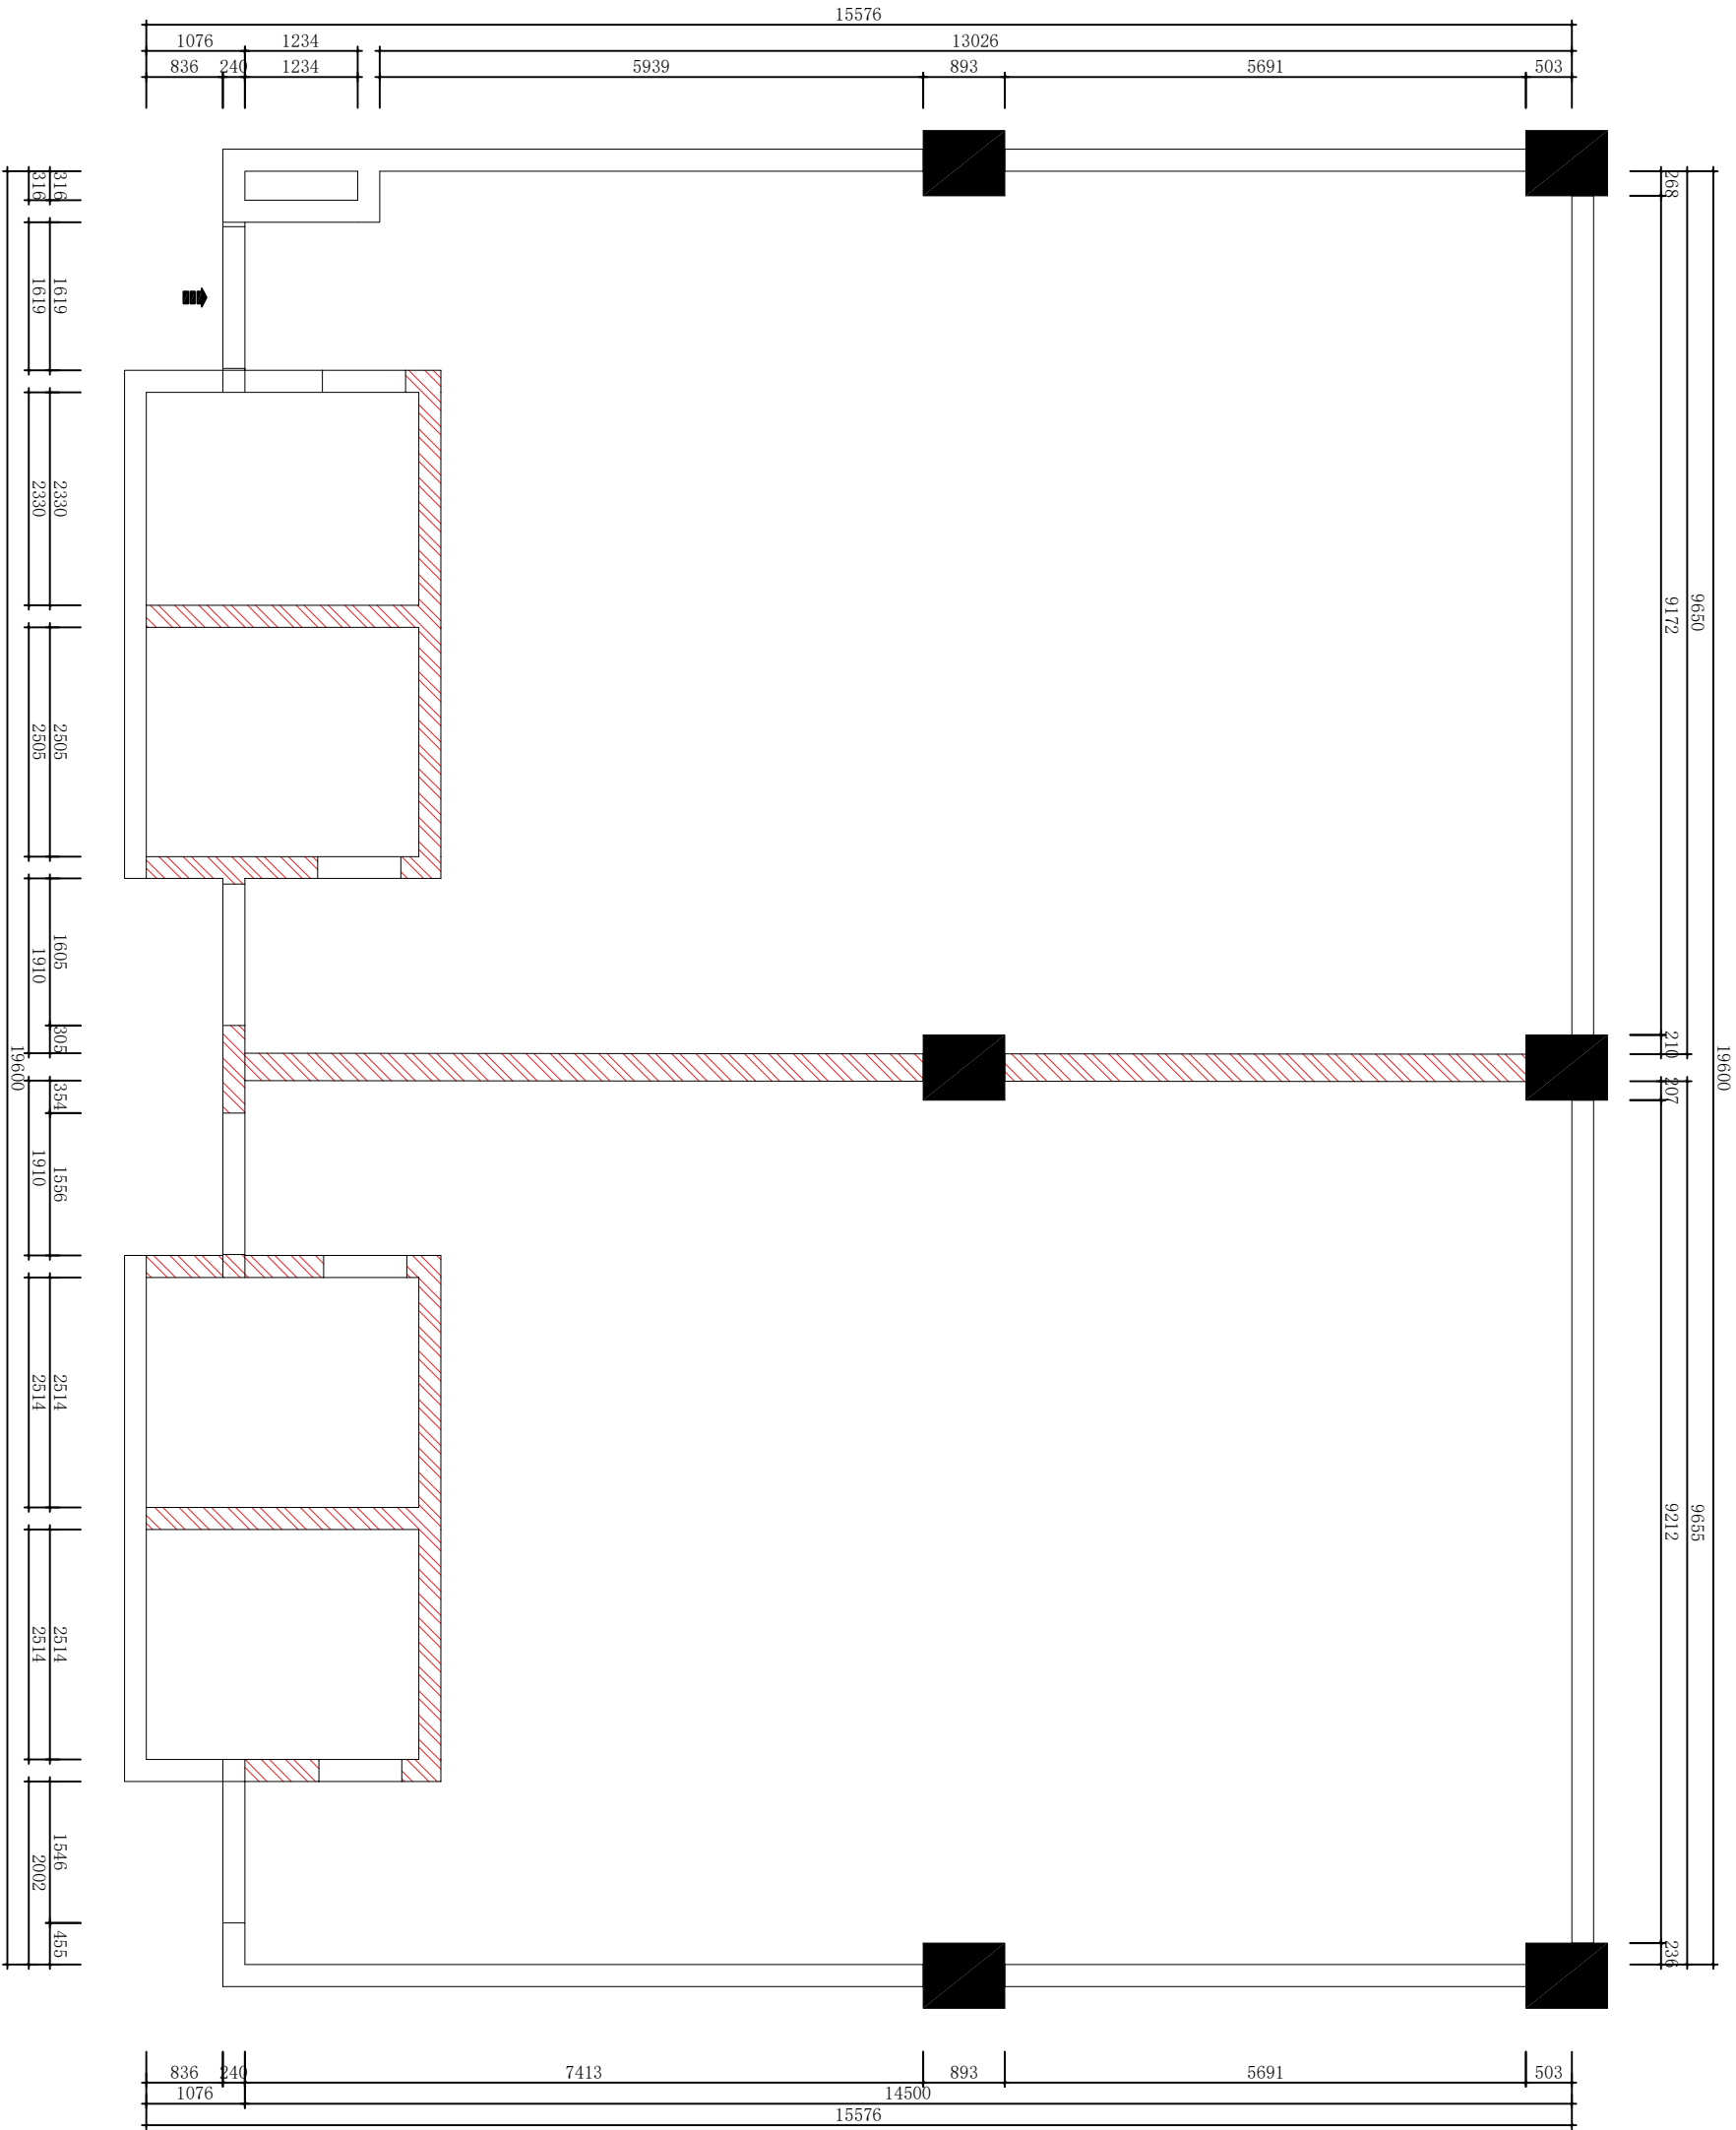


墙体拆除图

工程名称: PROJECT:	
图纸名称: TITLE:	
设计总监: DESIGNER IN CHIEF:	
签名: SIGNATURE:	
项目负责人: PROJECT IN CHIEF:	
签名: SIGNATURE:	
设计师: DESIGNER:	
审核: APPROVED BY:	
业主签名: CLIENT SIGNATURE:	
图纸编号: DRAWING NO:	
比例: SCALE:	日期: DATE:

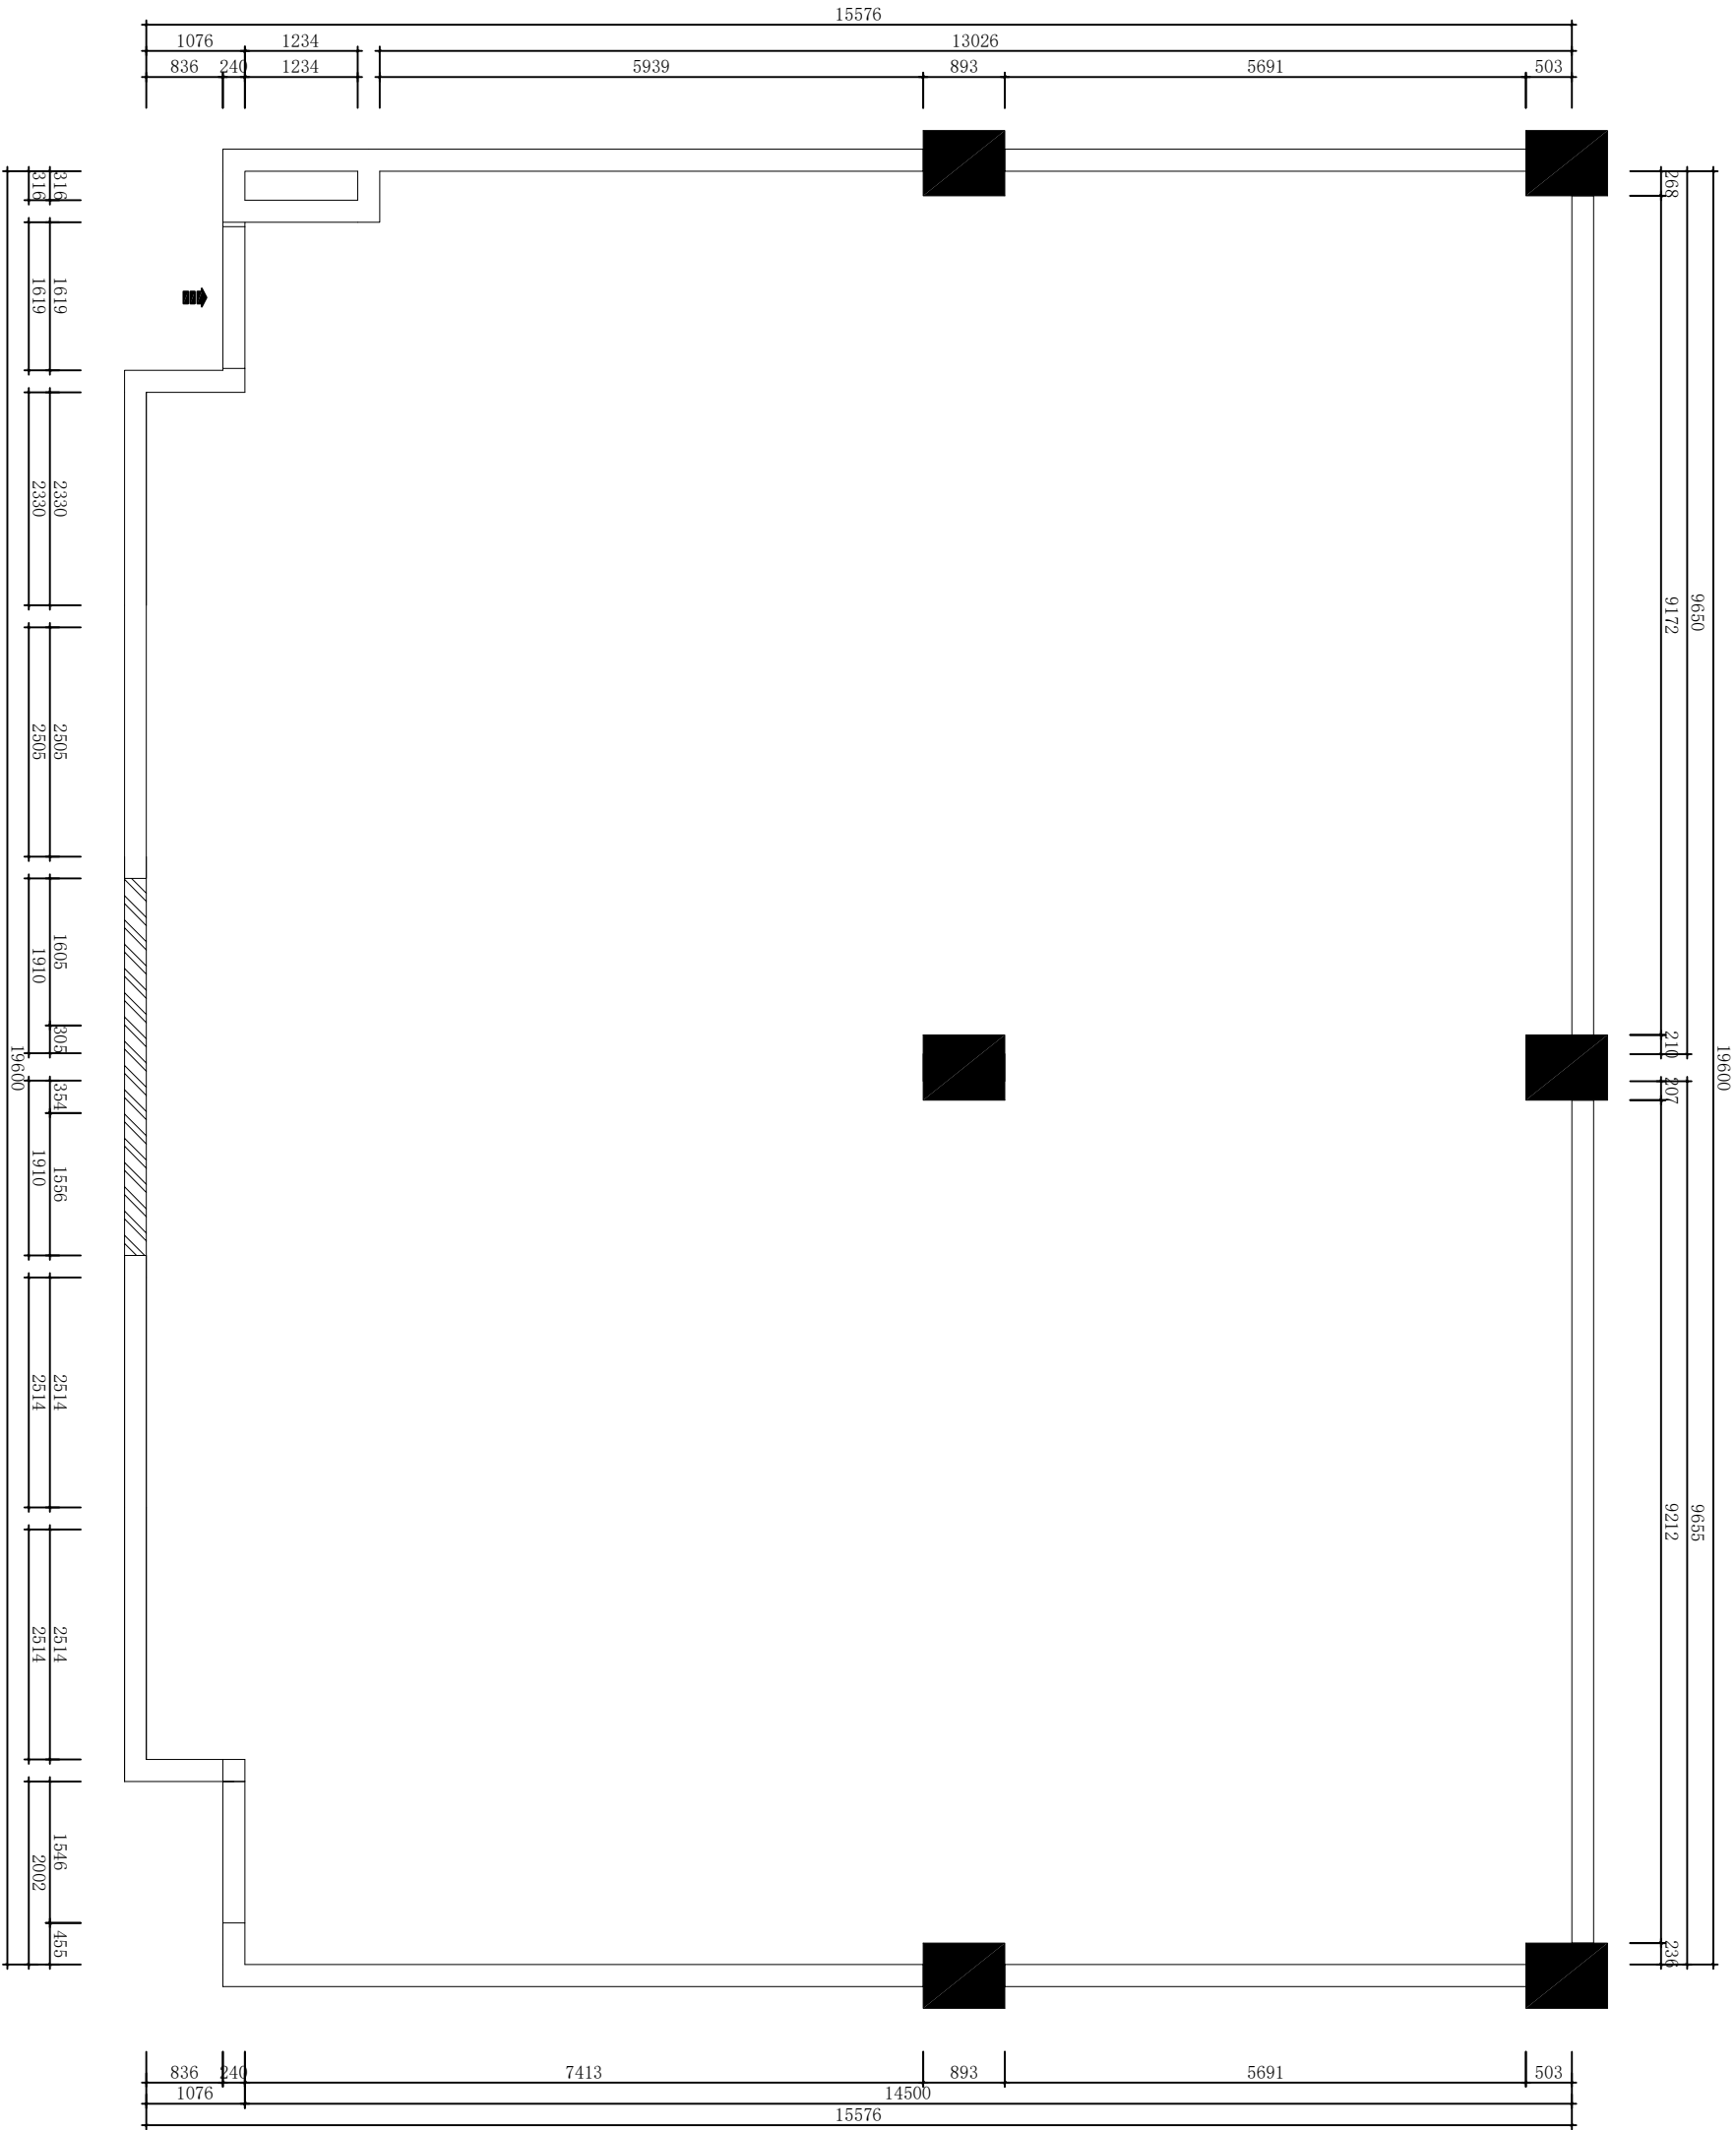


新建墙体图

工程名称: PROJECT:	
图纸名称: TITLE:	
设计总监: DESIGNER IN CHIEF:	签名: SIGNATURE:
项目负责人: PROJECT IN CHIEF:	签名: SIGNATURE:
设计师: DESIGNER:	
审核: APPROVED BY:	
业主签名: CLIENT SIGNATURE:	
图纸编号: DRAWING NO:	
比例: SCALE:	日期: DATE:


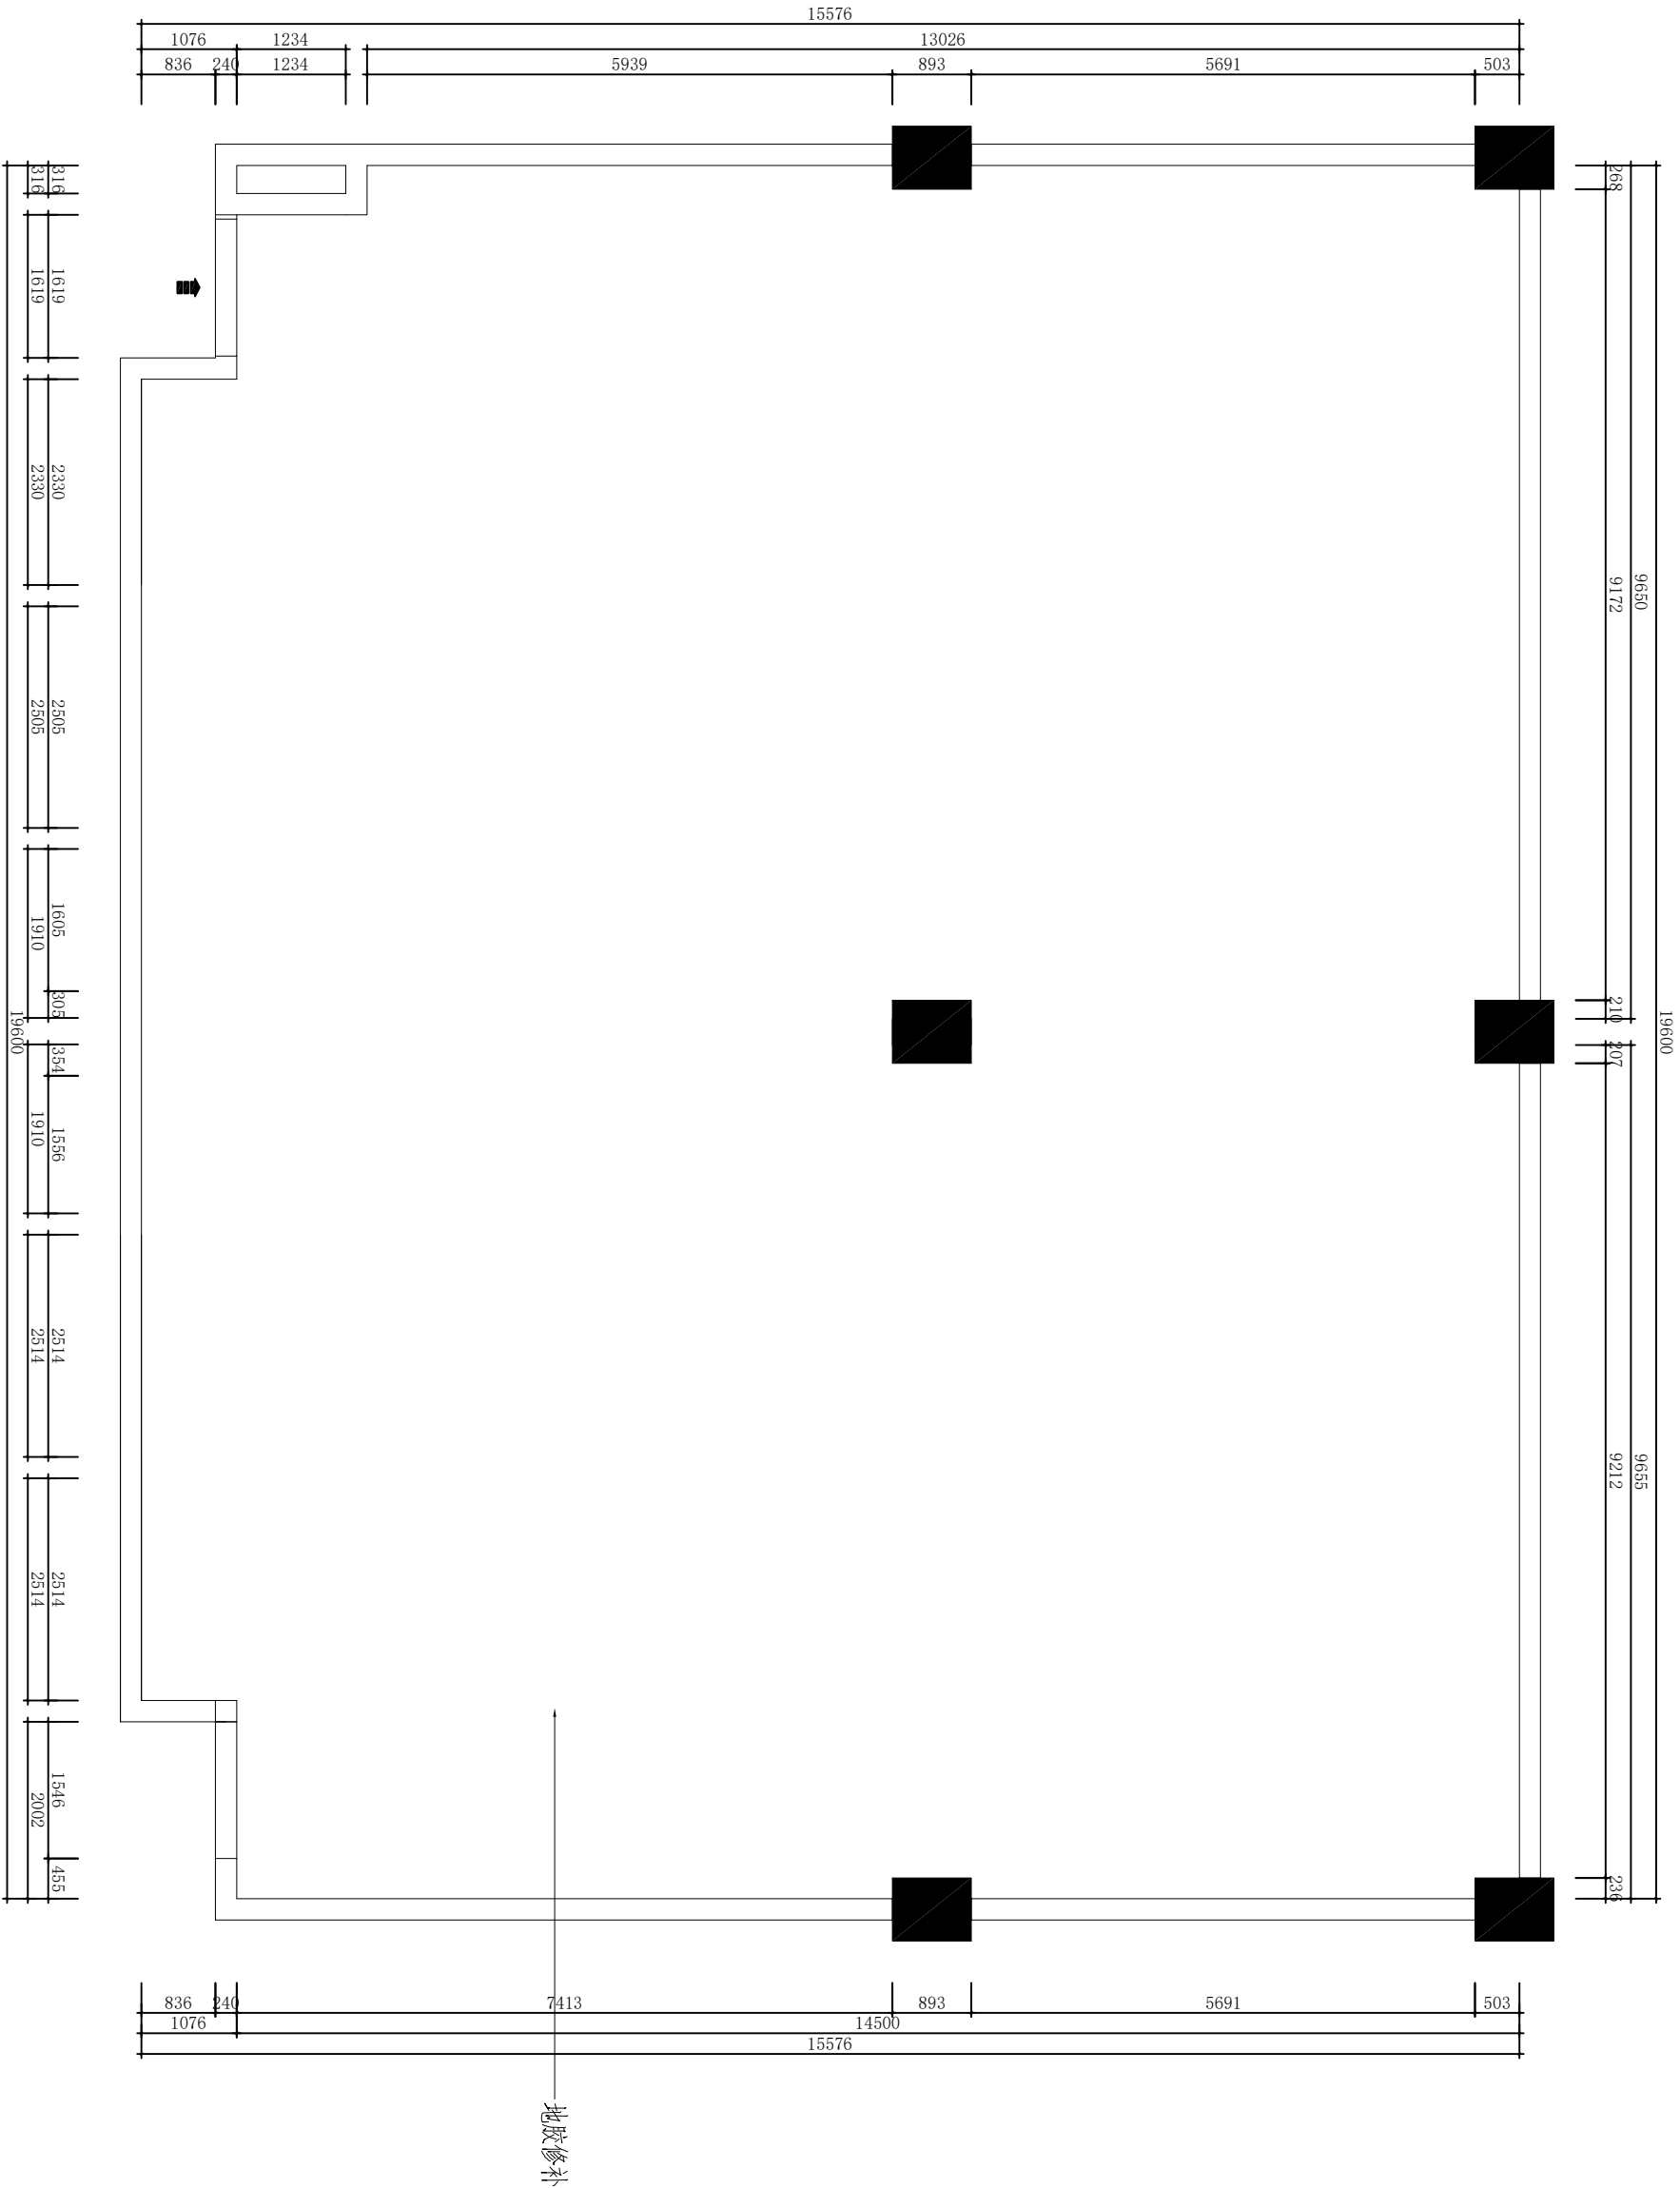


地面施工图

工程名称: PROJECT:	
图纸名称: TITLE:	
设计总监: DESIGNER IN CHIEF:	
签名: SIGNATURE:	
项目负责人: PROJECT IN CHIEF:	
签名: SIGNATURE:	
设计师: DESIGNER:	
审核: APPROVED BY:	
业主签名: CLIENT SIGNATURE:	
图纸编号: DRAWING NO:	
比例: SCALE:	日期: DATE:

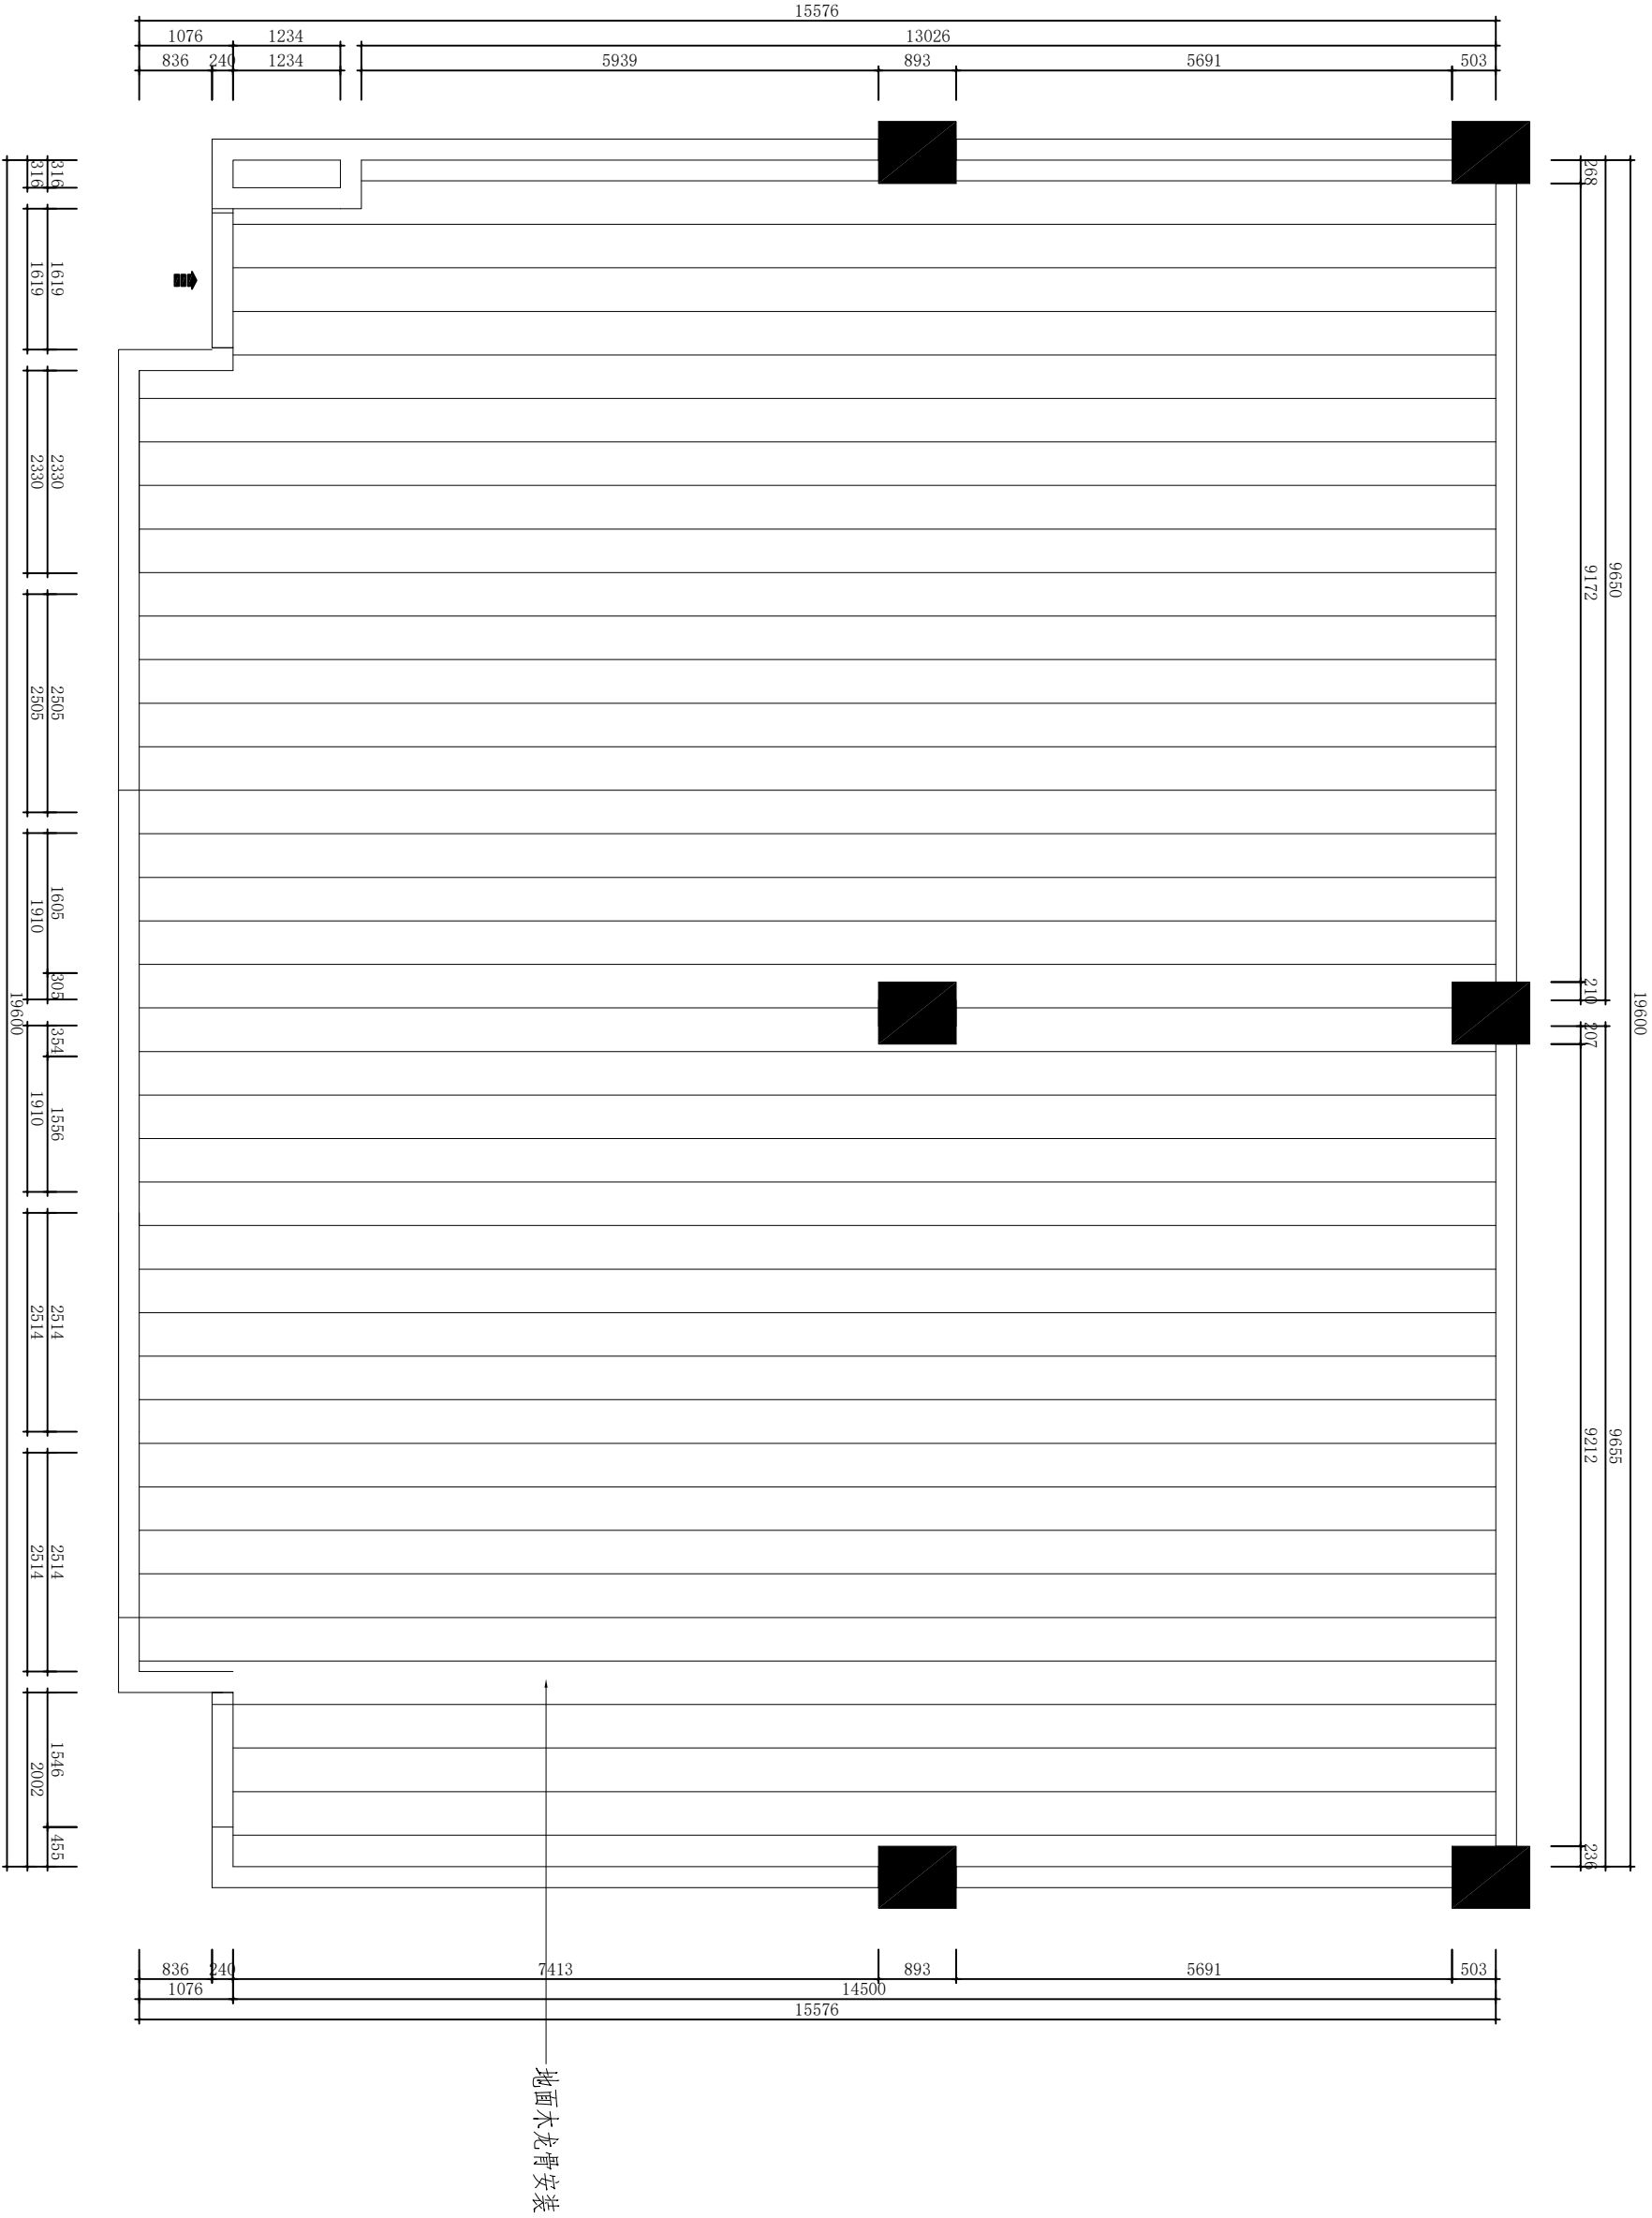


工程名称: PROJECT:		
图纸名称: TITLE:		
设计总监: DESIGNER IN CHIEF:		
签名: SIGNATURE:		
项目负责人: PROJECT IN CHIEF:		
签名: SIGNATURE:		
设计师: DESIGNER:		
审核: APPROVED BY:		
业主签名: CLIENT SIGNATURE:		
图纸编号: DRAWING NO:		
比例: SCALE:	日期: DATE:	

 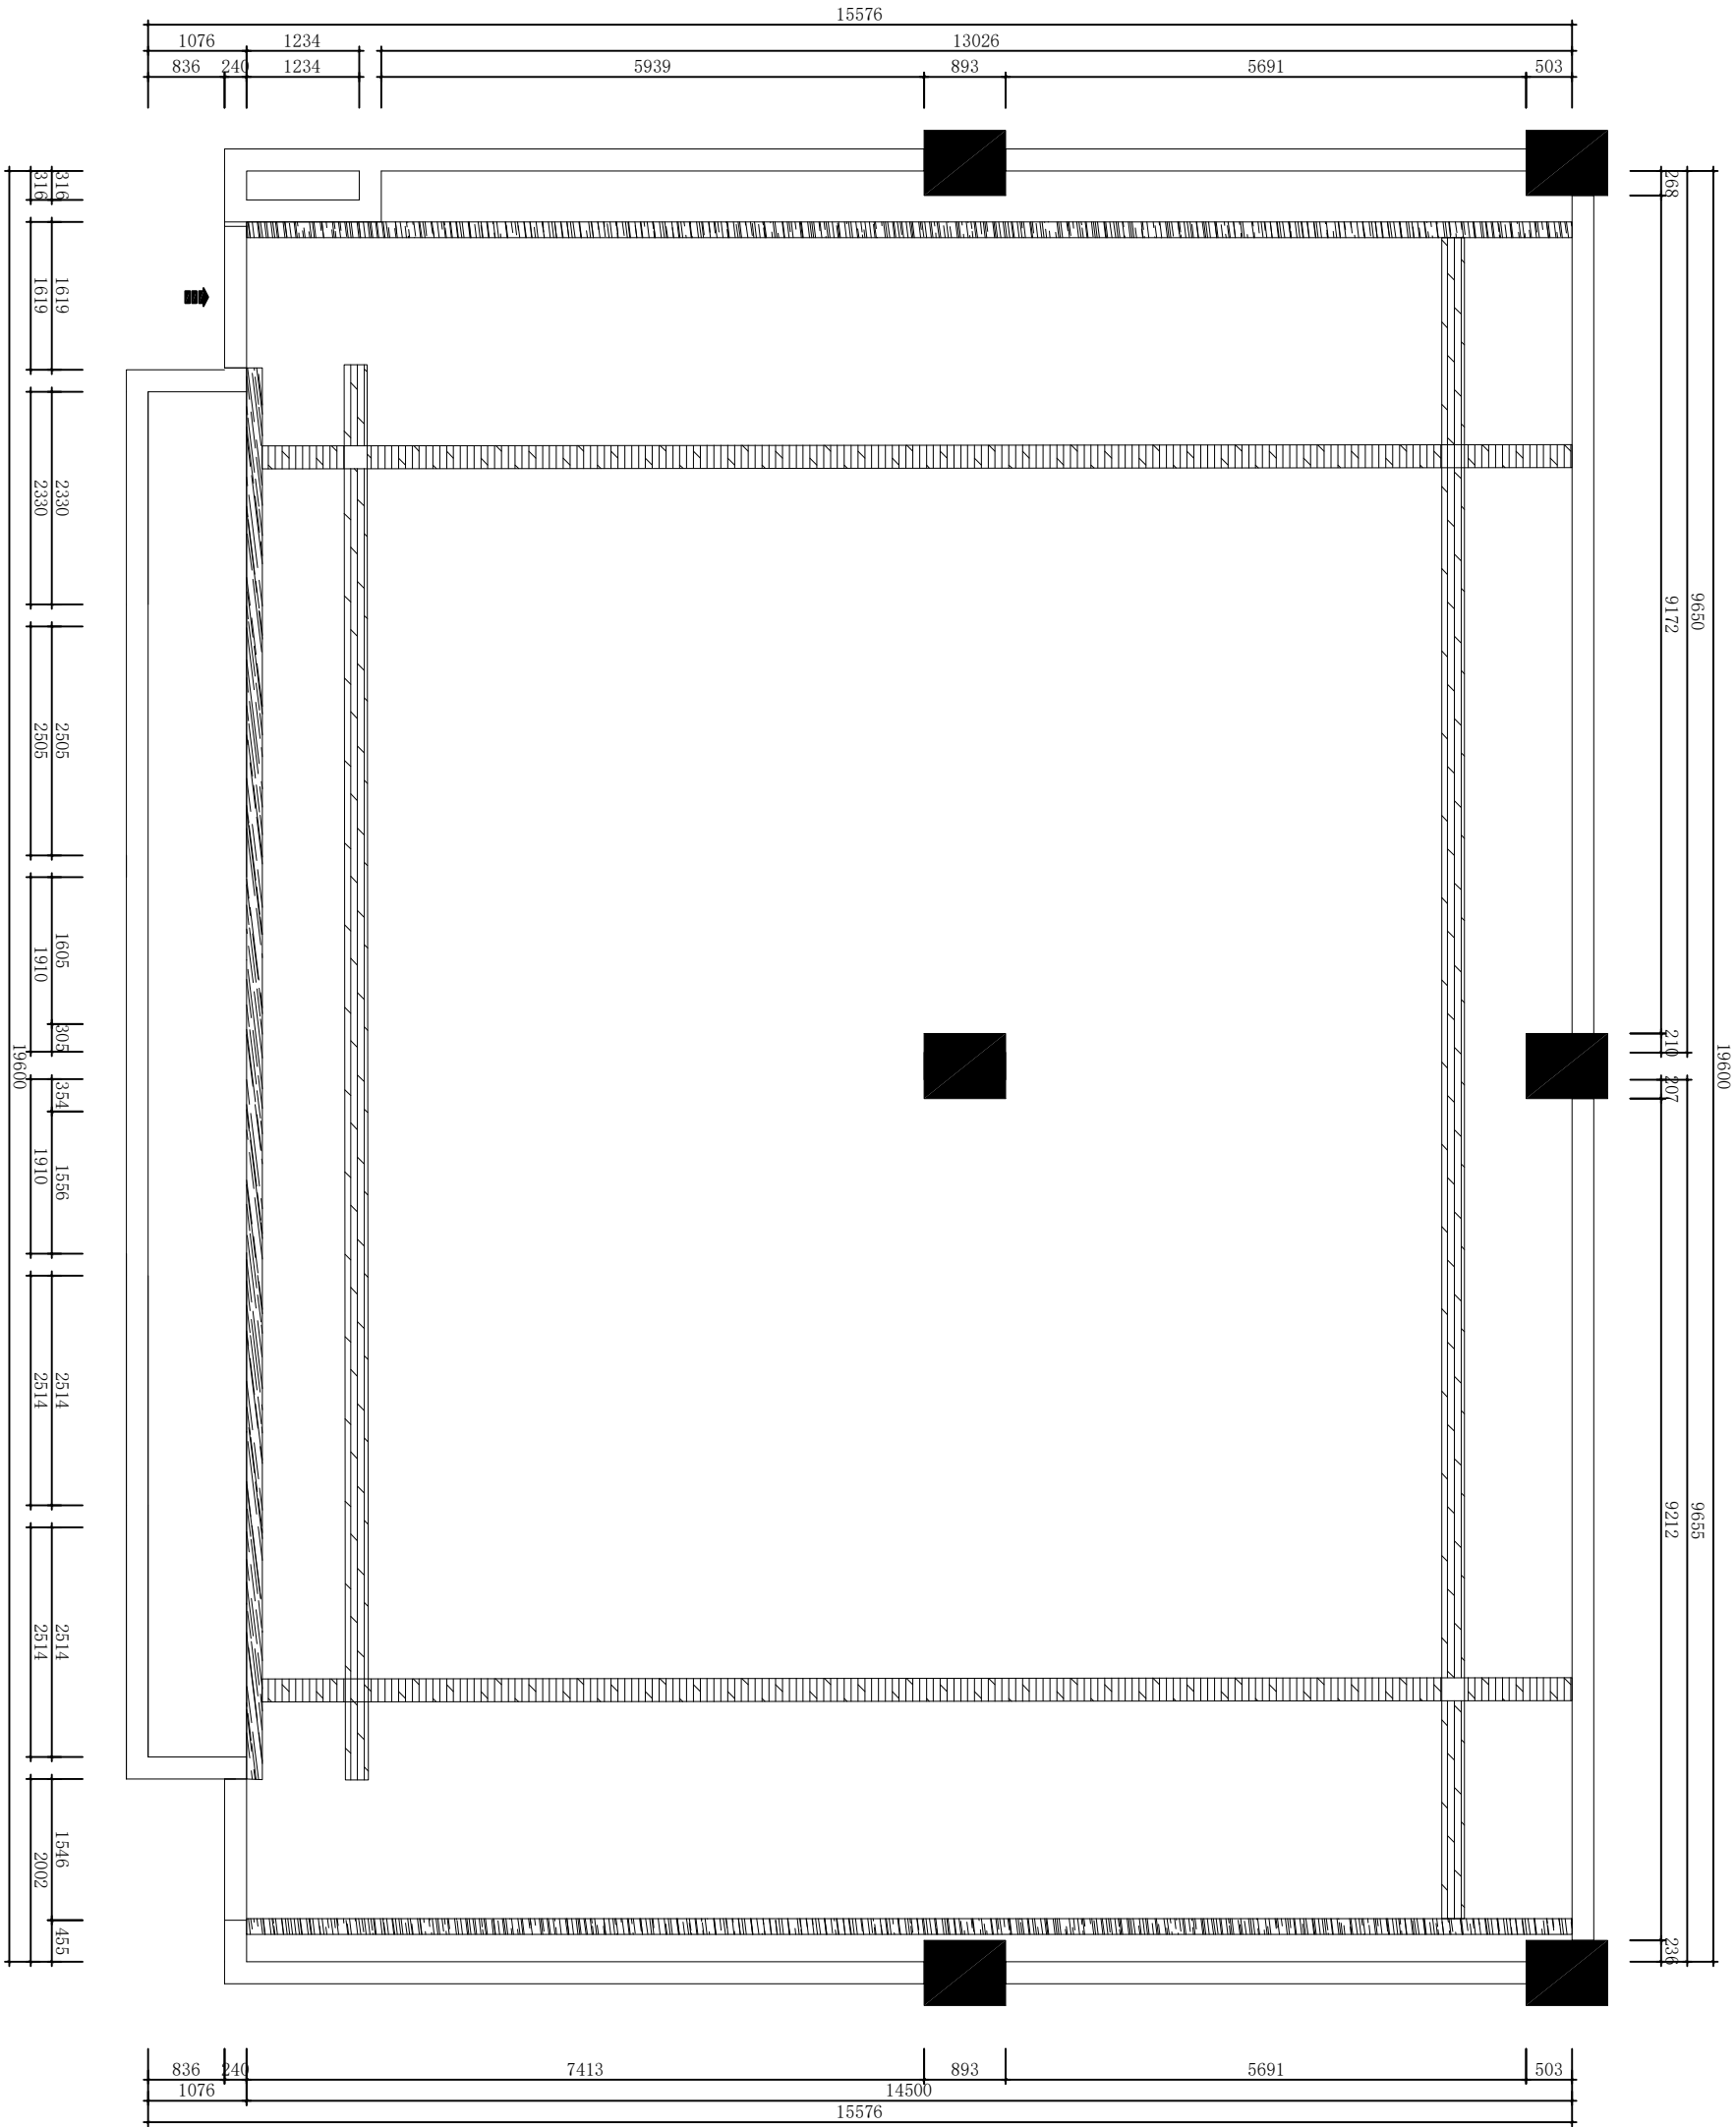

银镜
舞蹈栏杆


银镜/栏杆安装

工程名称: PROJECT:	
图纸名称: TITLE:	
设计总监: DESIGNER IN CHIEF:	
签名: SIGNATURE:	
项目负责人: PROJECT IN CHIEF:	
签名: SIGNATURE:	
设计师: DESIGNER:	
审核: APPROVED BY:	
业主签名: CLIENT SIGNATURE:	
图纸编号: DRAWING NO:	
比例: SCALE:	日期: DATE:

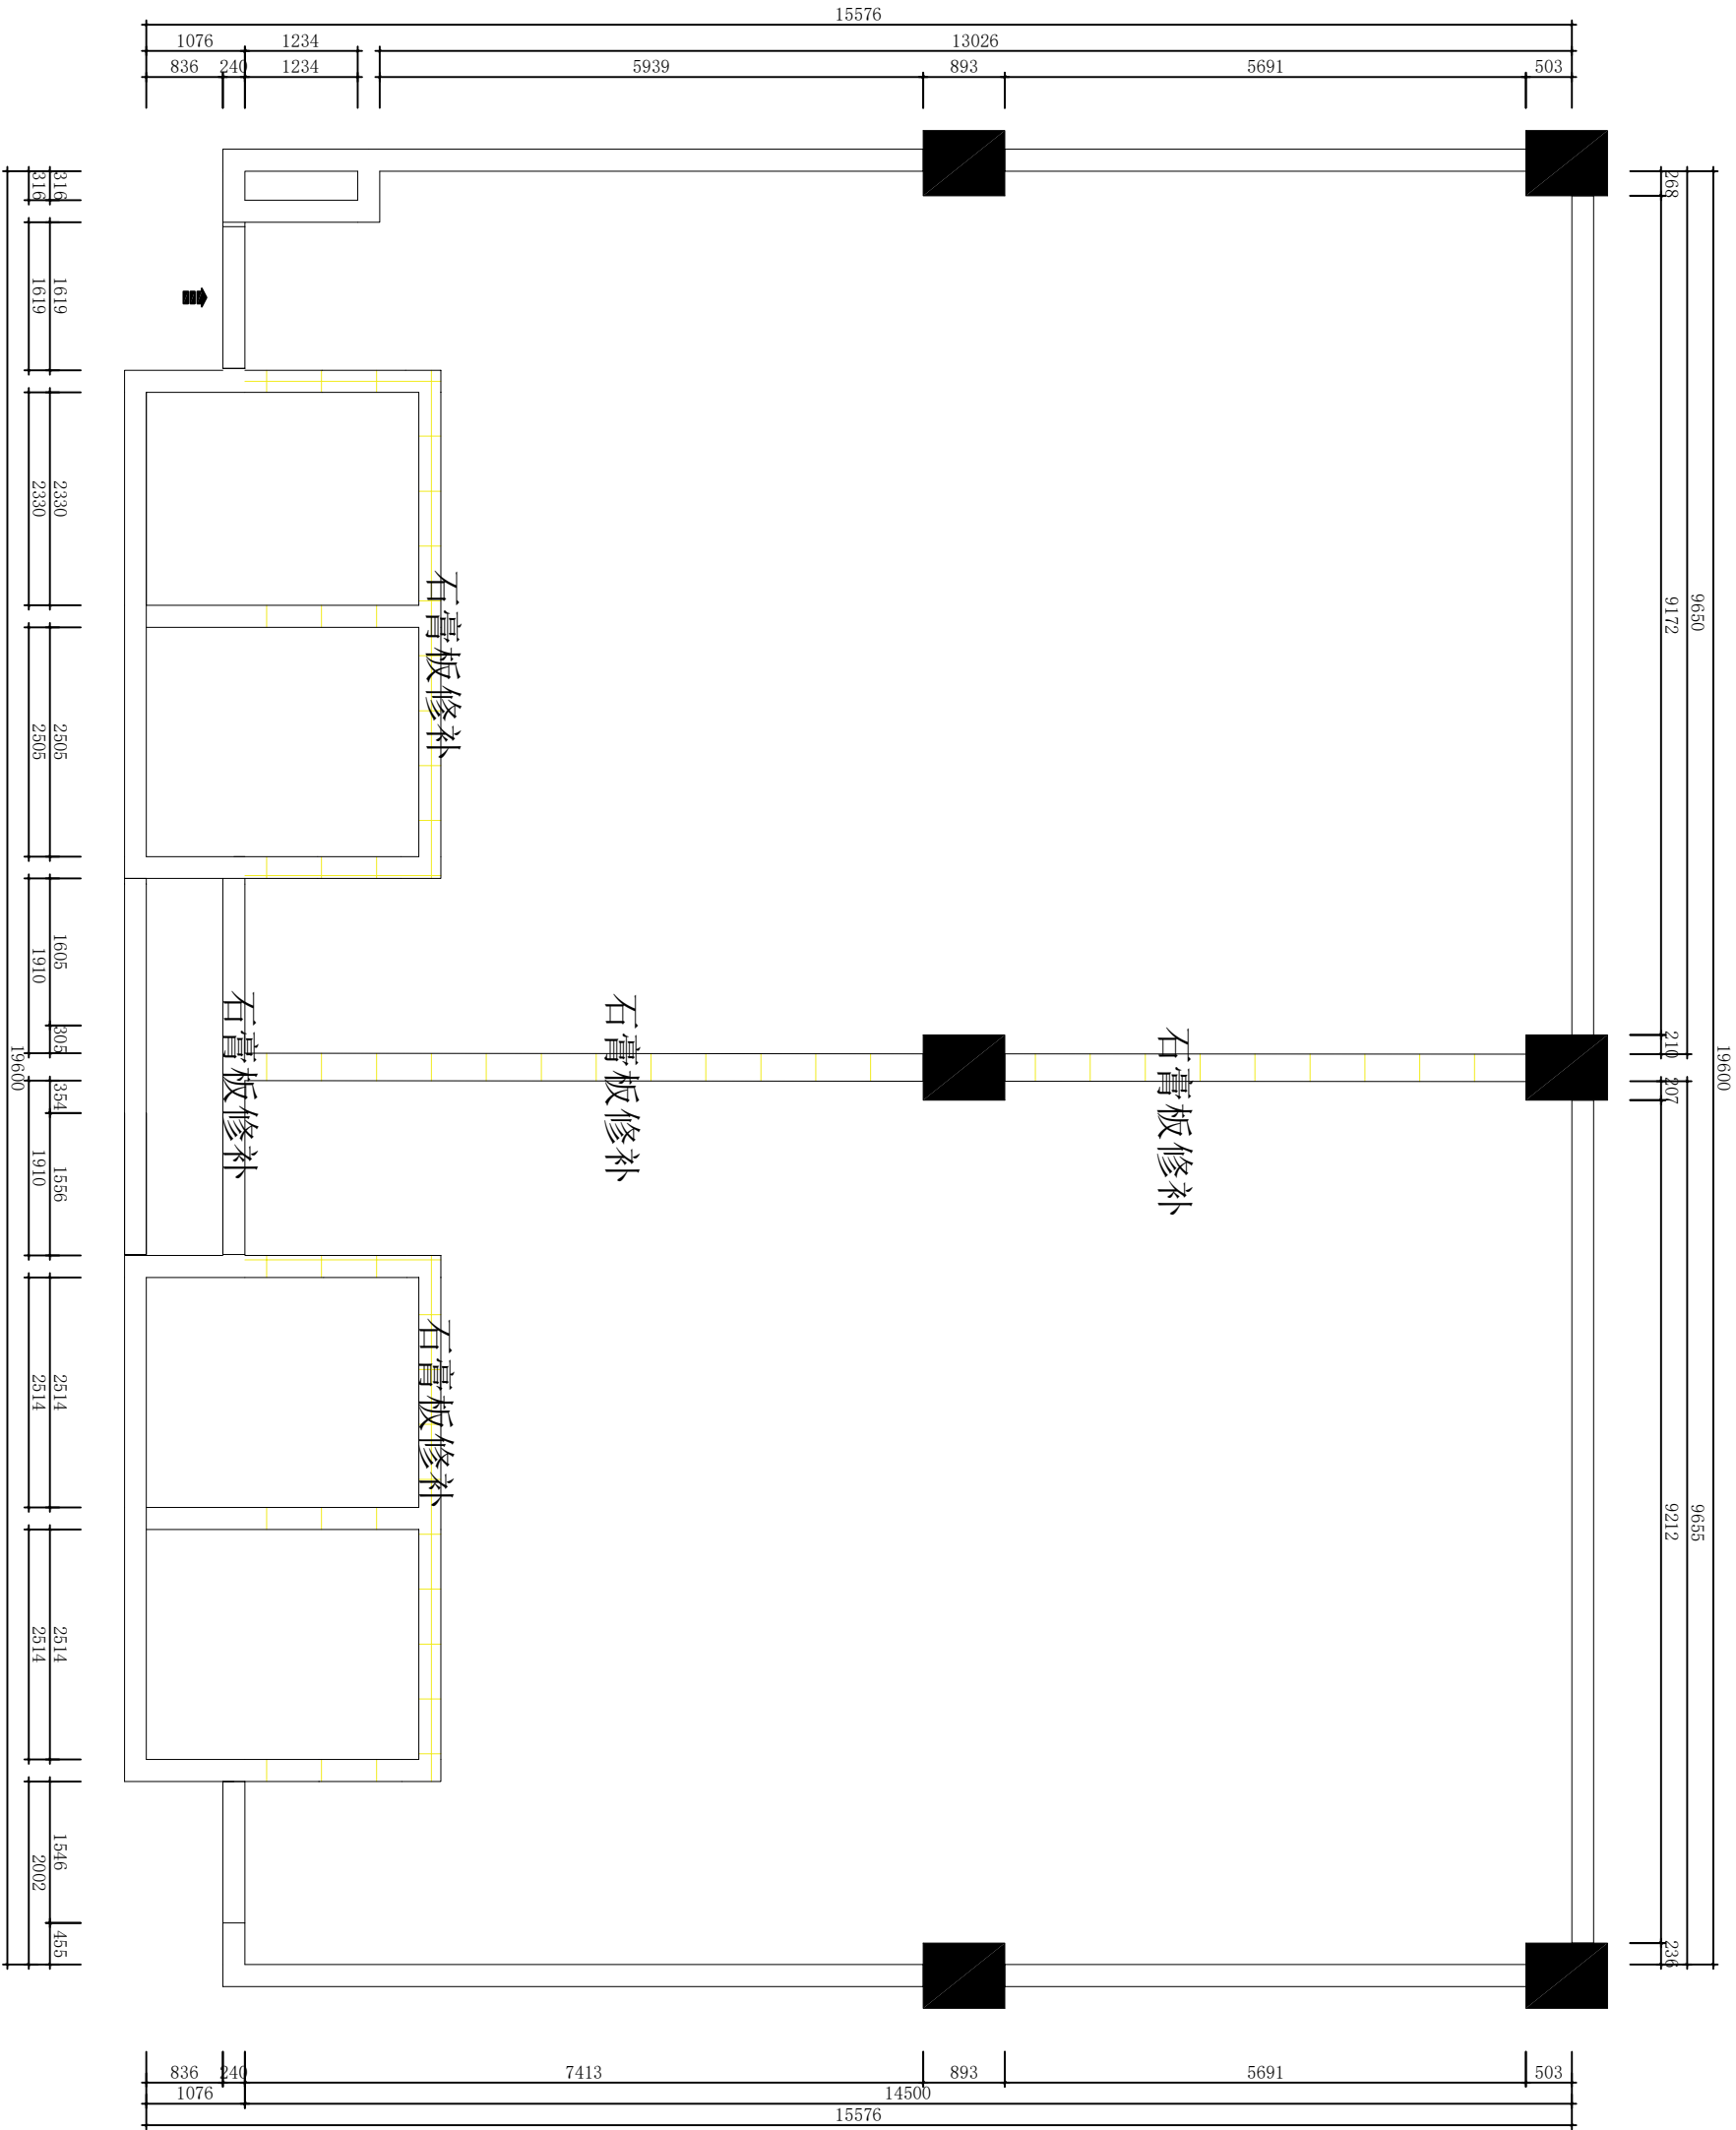


顶面石膏板修补图

工程名称: PROJECT:		
图纸名称: TITLE:		
设计总监: DESIGNER IN CHIEF:	签名: SIGNATURE:	
项目负责人: PROJECT IN CHIEF:	签名: SIGNATURE:	
设计师: DESIGNER:		
审核: APPROVED BY:		
业主签名: CLIENT SIGNATURE:		
图纸编号: DRAWING NO:		
比例: SCALE:	日期: DATE:	

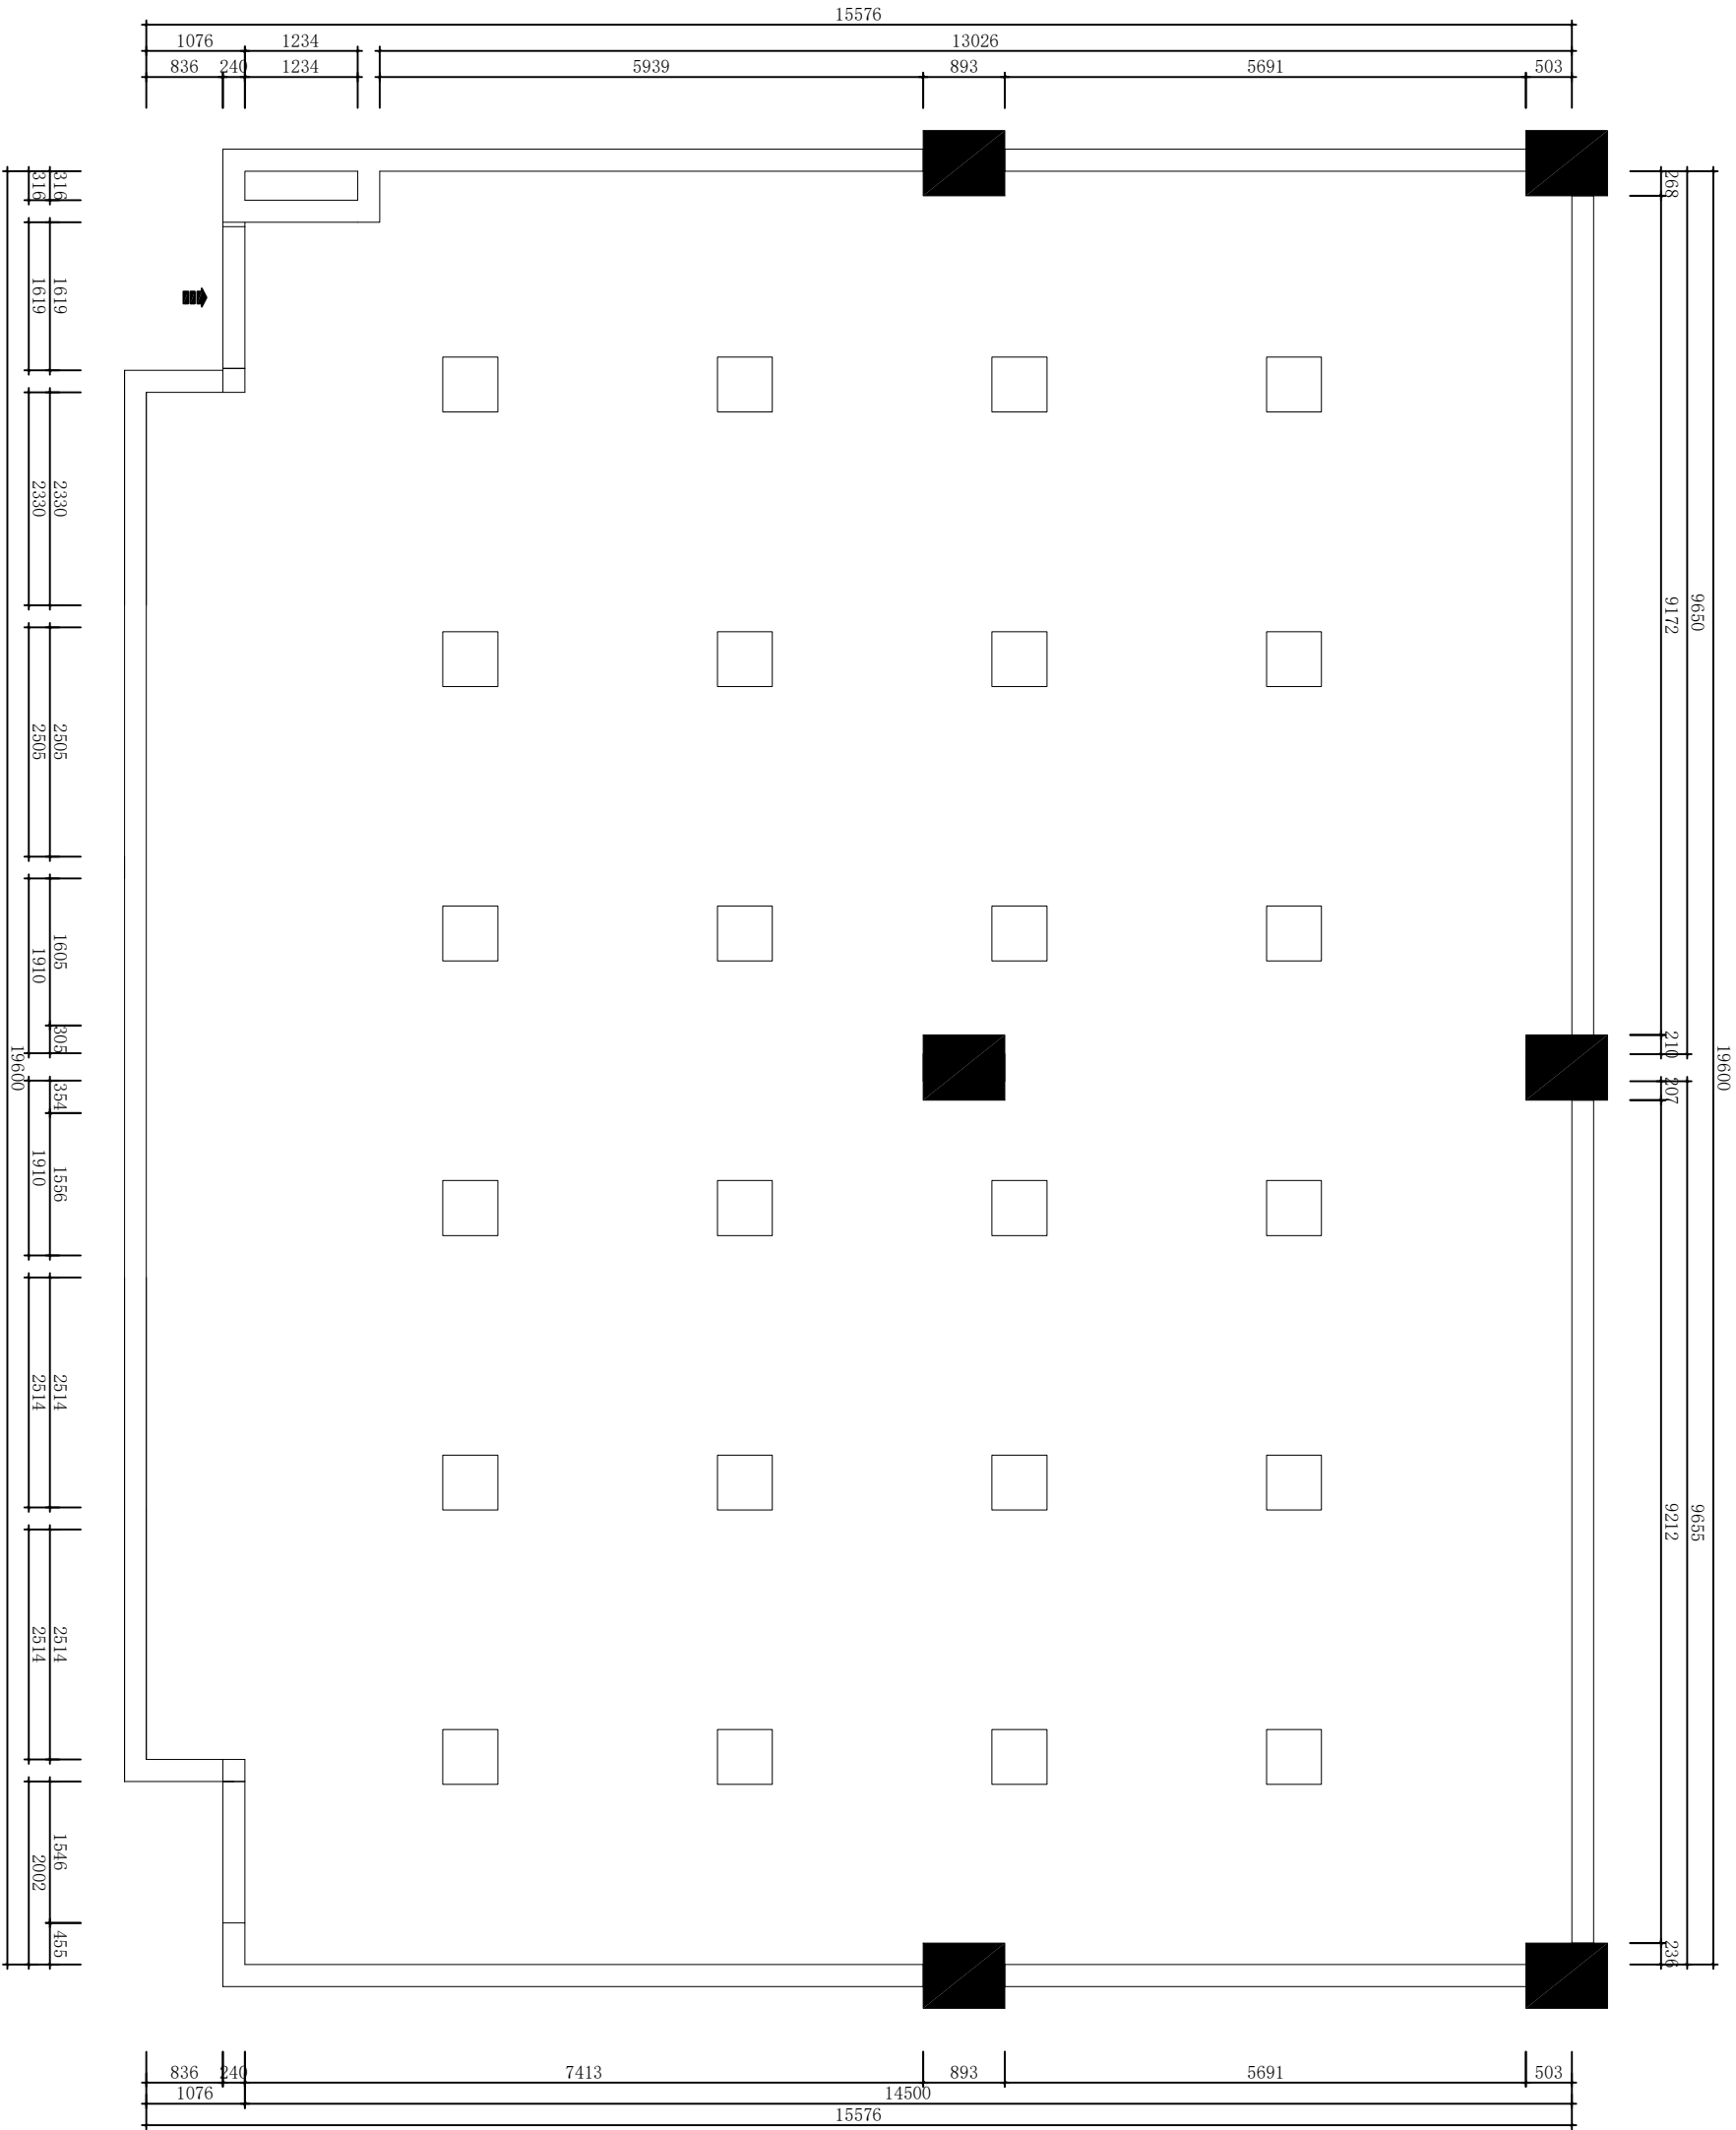

顶面布置图

工程名称: PROJECT:		
图纸名称: TITLE:		
设计总监: DESIGNER IN CHIEF:		
签名: SIGNATURE:		
项目负责人: PROJECT IN CHIEF:		
签名: SIGNATURE:		
设计师: DESIGNER:		
审核: APPROVED BY:		
业主签名: CLIENT SIGNATURE:		
图纸编号: DRAWING NO:		
比例: SCALE:	日期: DATE:	

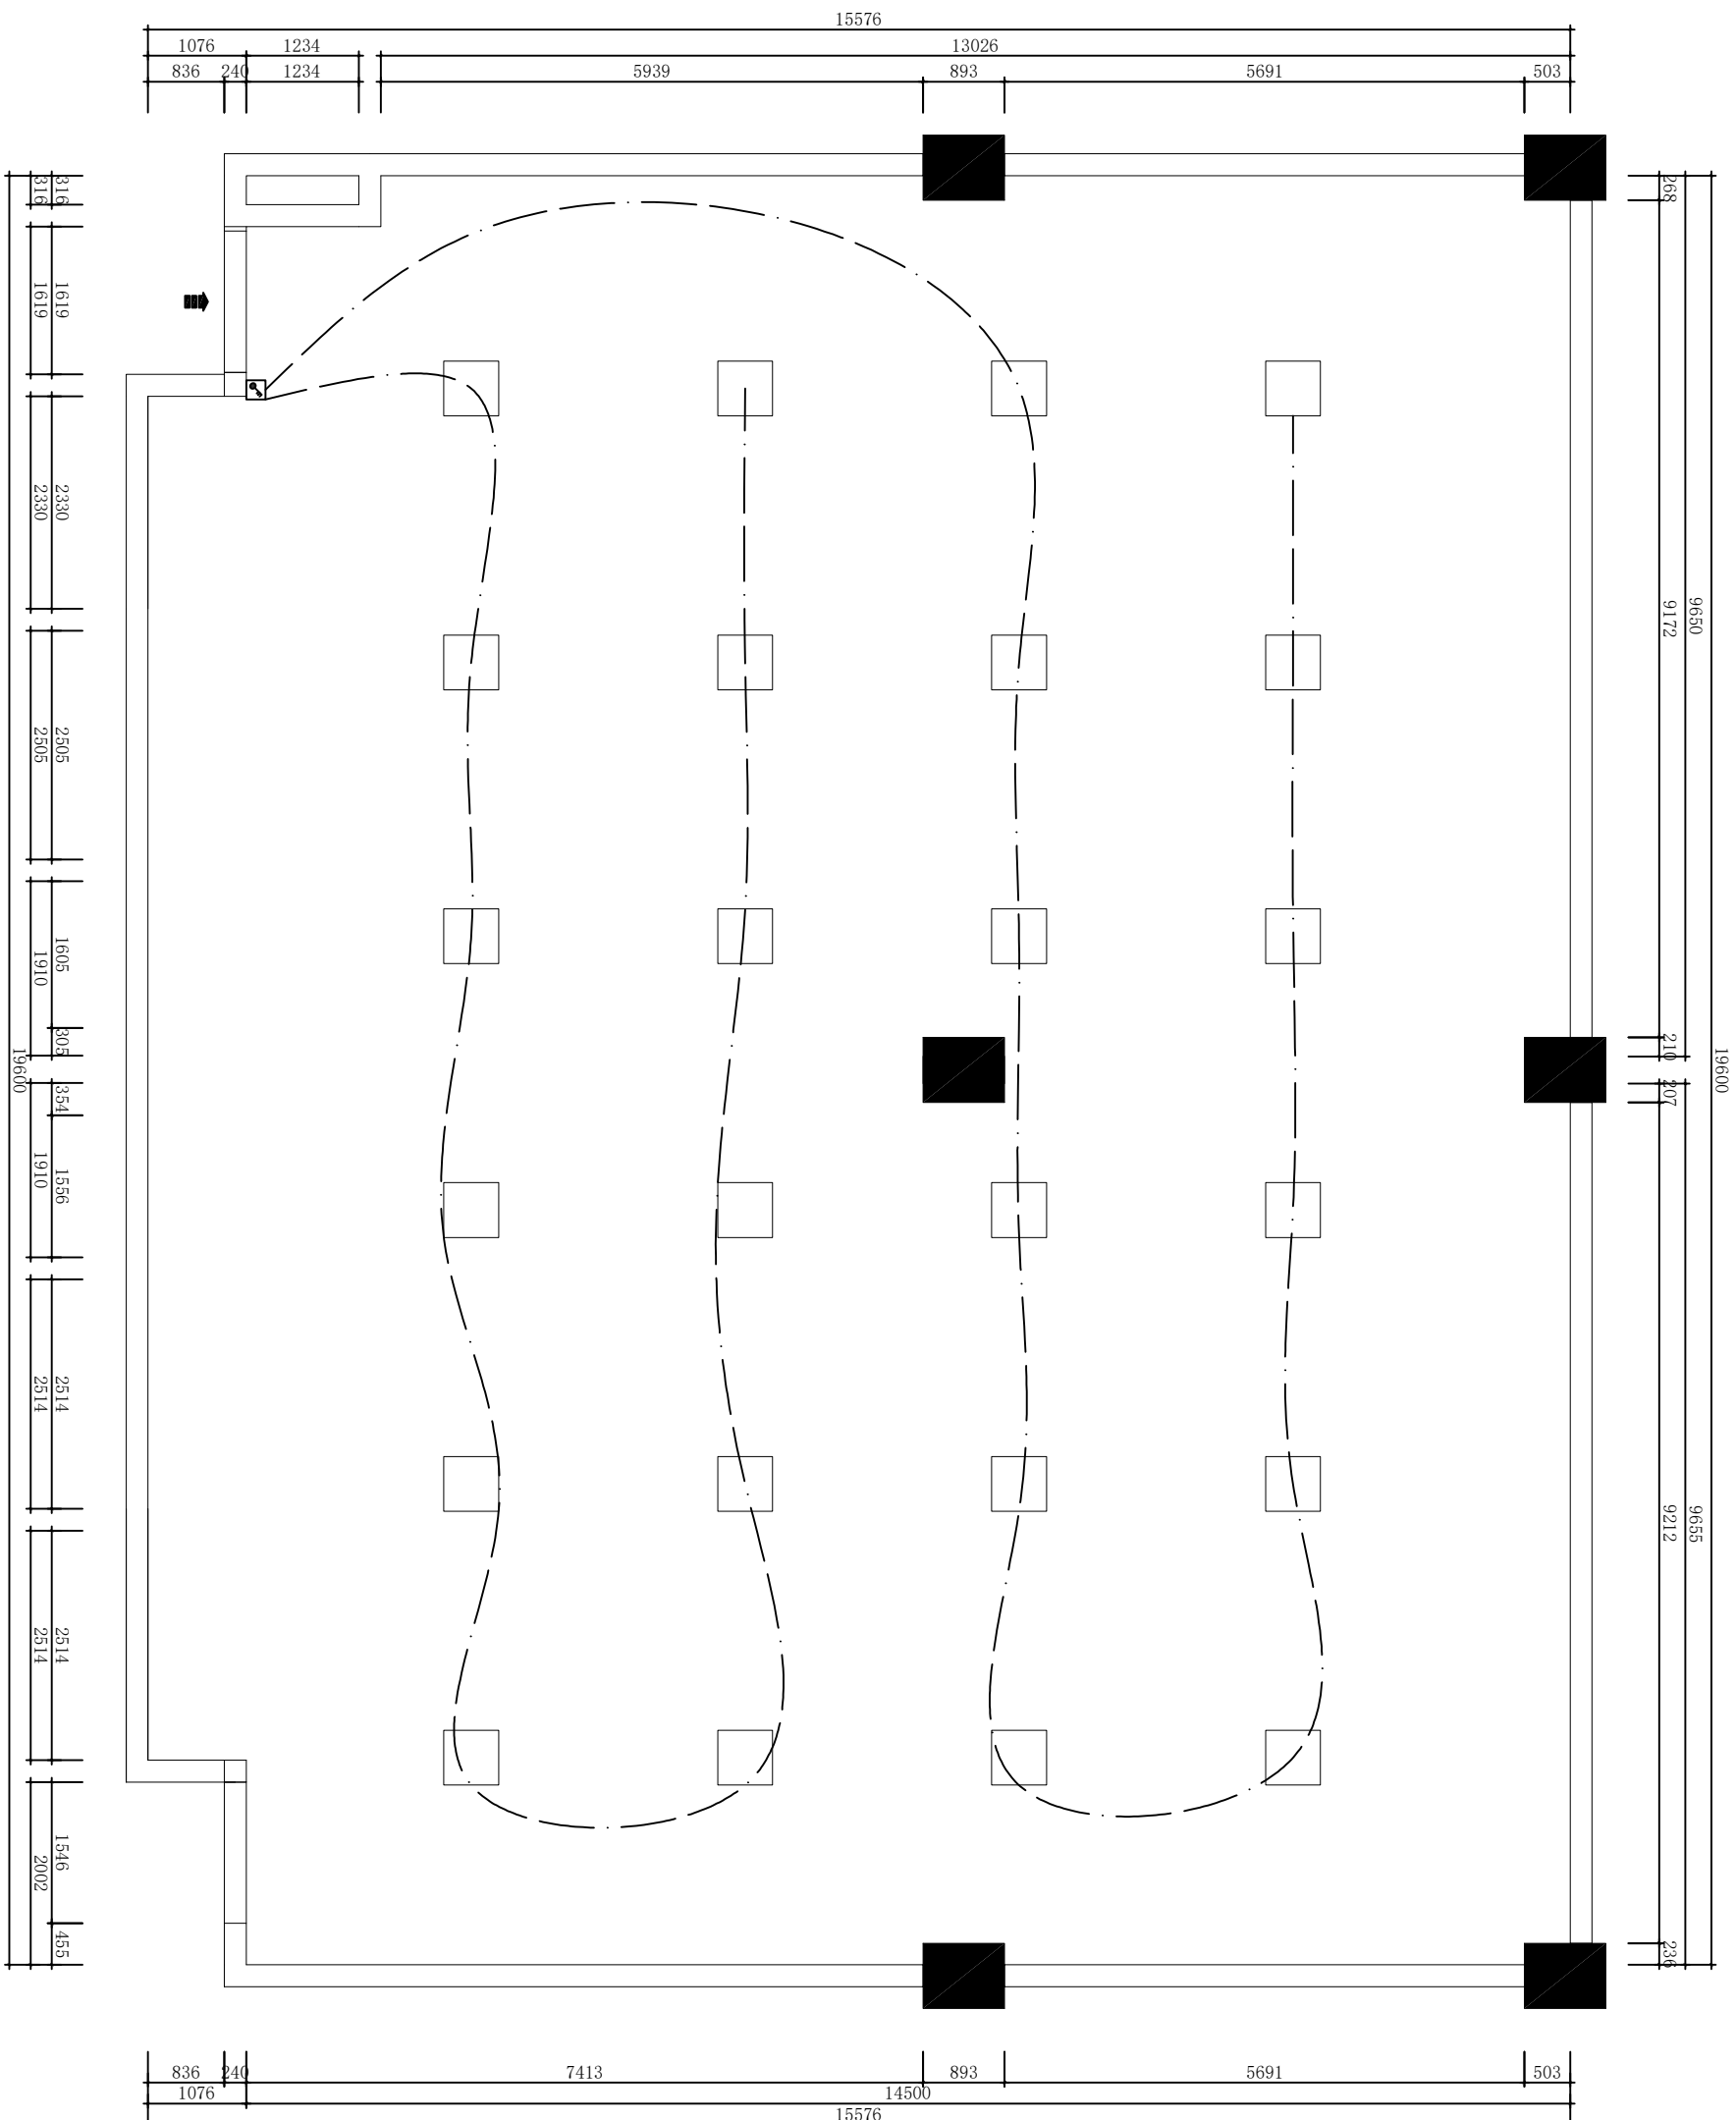


灯控图

除特别标注外，下边距地1.3米

除特别标注外,下边距1.3米

三联单控 除特别标注外, 下边距地1.3米


工程名称: PROJECT:	
图纸名称: TITLE:	
设计总监: DESIGNER IN CHIEF:	
签名: SIGNATURE:	
项目负责人: PROJECT IN CHIEF:	
签名: SIGNATURE:	
设计师: DESIGNER:	
审核: APPROVED BY:	
业主签名: CLIENT SIGNATURE:	
图纸编号: DRAWING NO.:	
比例: SCALE:	日期: DATE:

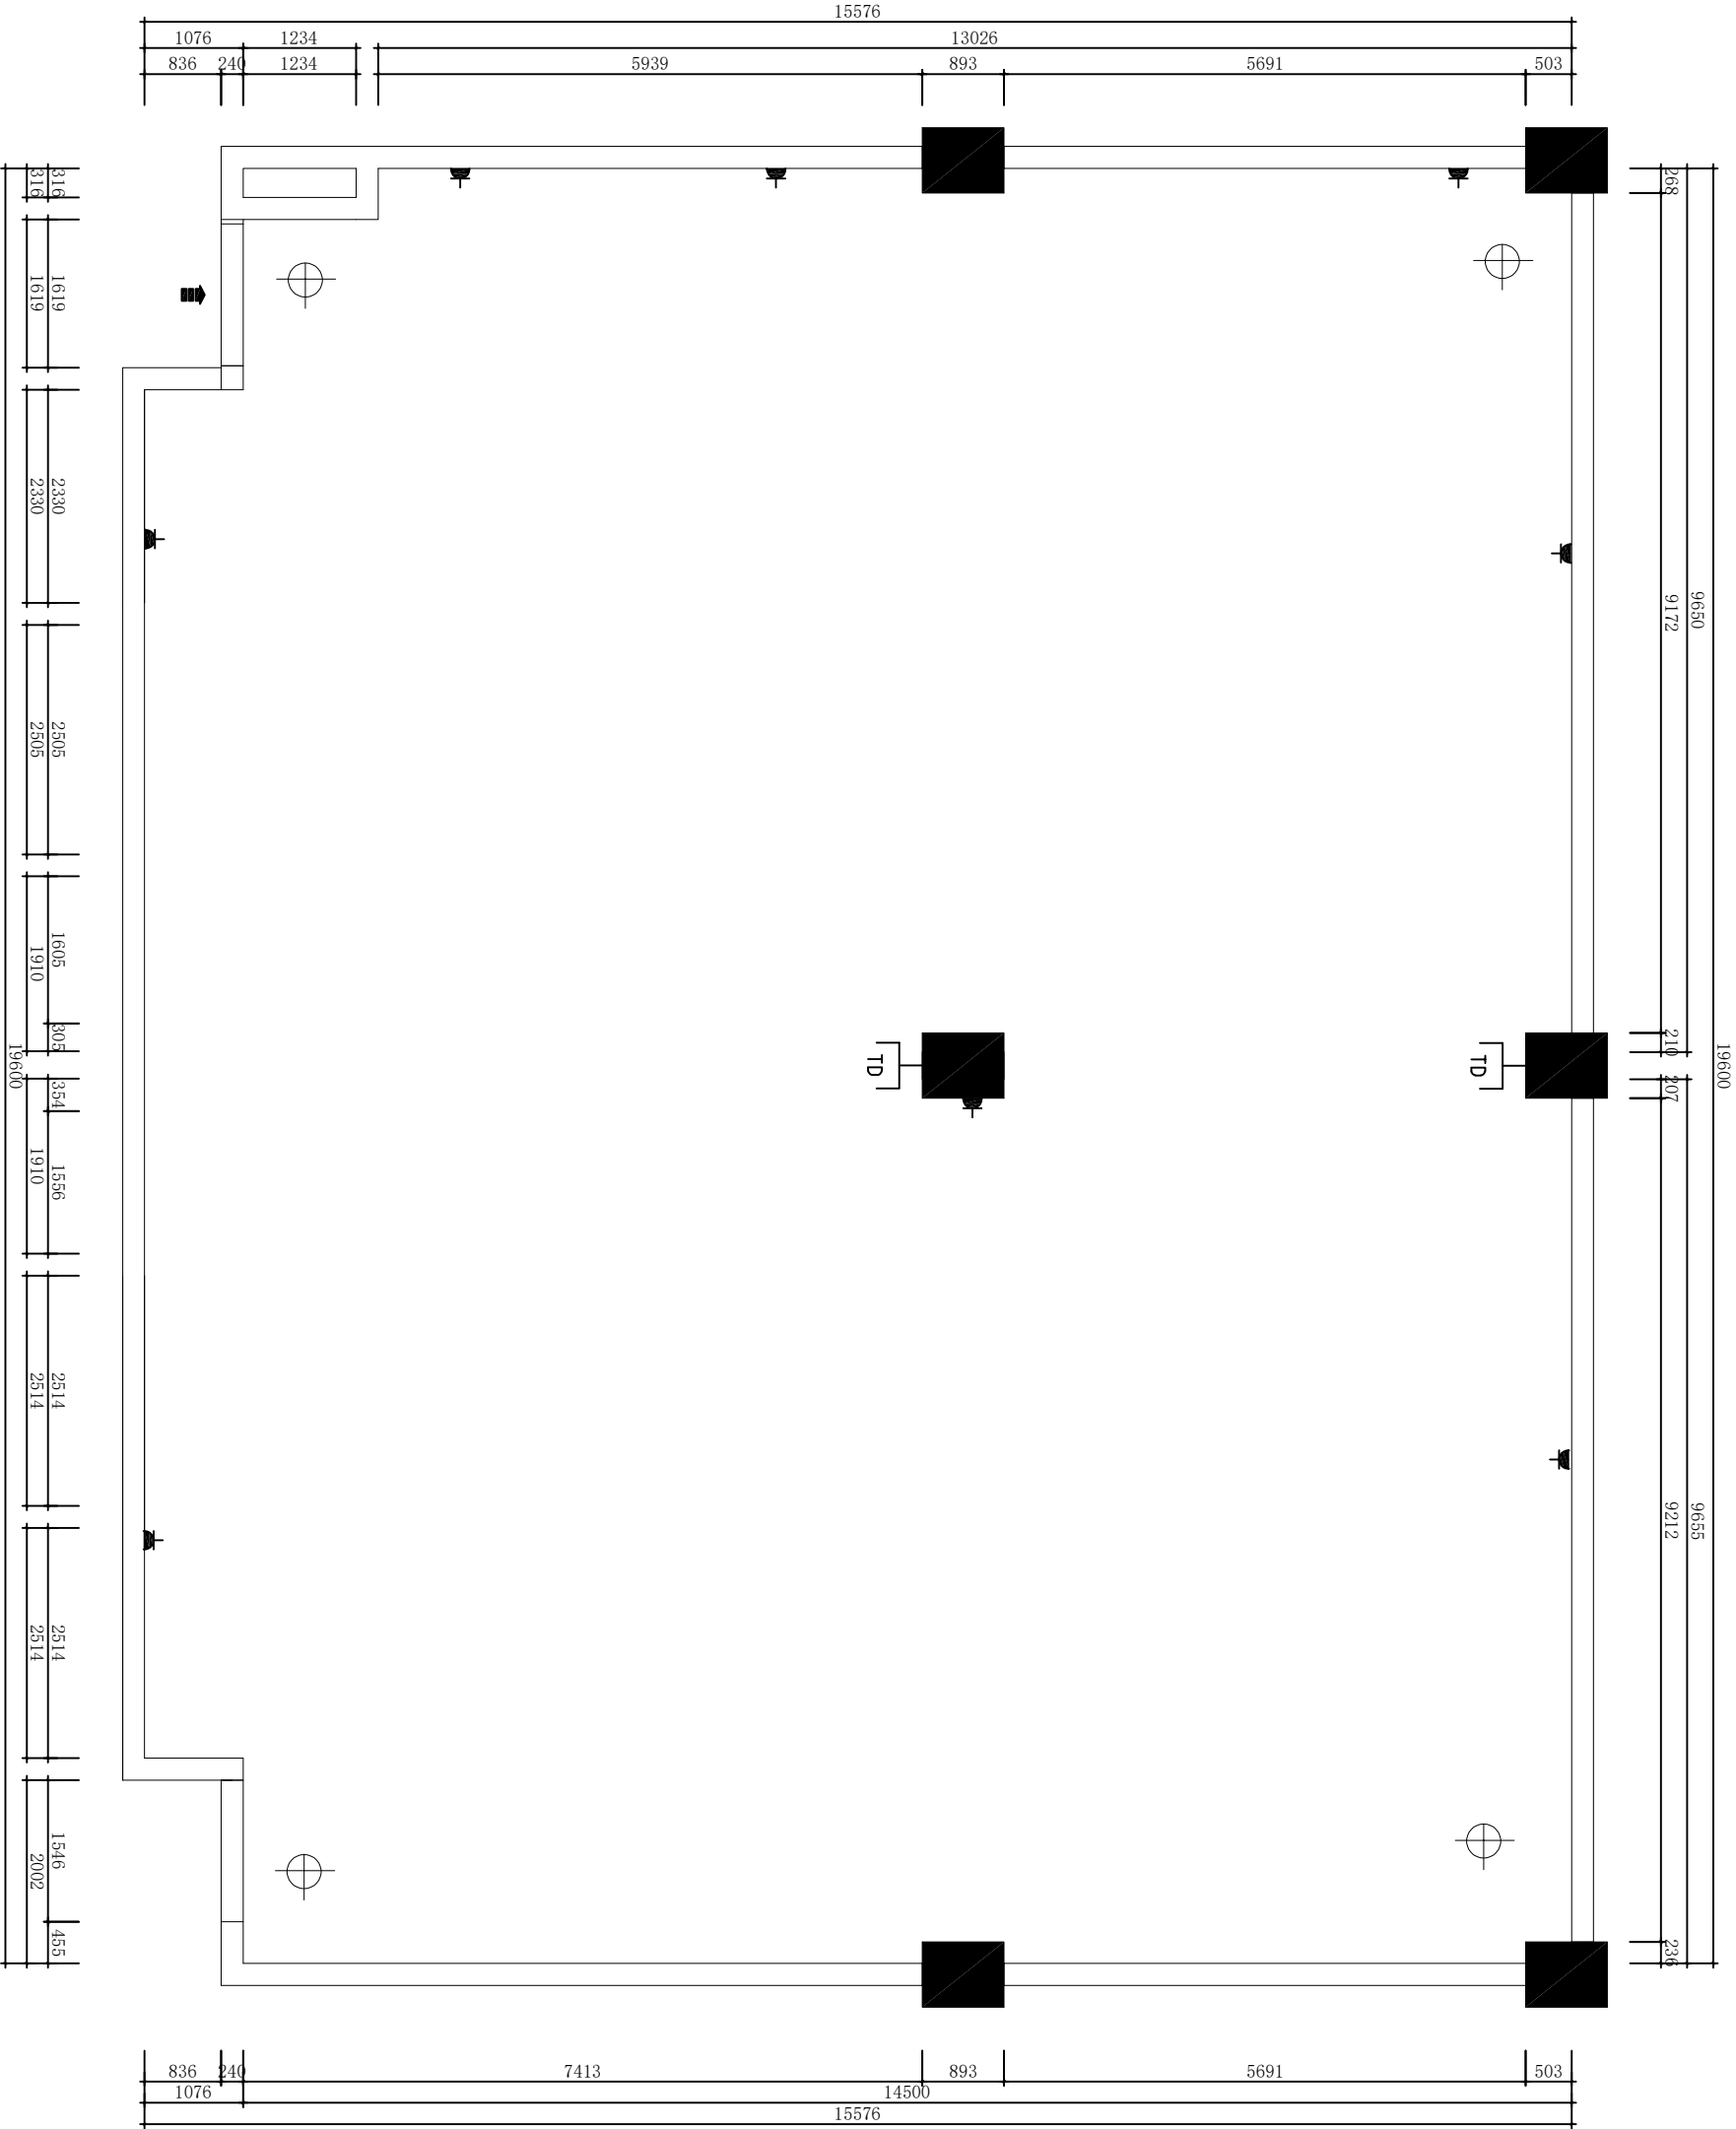

强弱电布置图



 监控



五孔插座, 为标准高度均为300mm



五孔插座, 为标准高度均为300mm

工程名称: PROJECT:		
图纸名称: TITLE:		
设计总监: DESIGNER IN CHIEF:		
签名: SIGNATURE:		
项目负责人: PROJECT IN CHIEF:		
签名: SIGNATURE:		
设计师: DESIGNER:		
审核: APPROVED BY:		
业主签名: CLIENT SIGNATURE:		
图纸编号: DRAWING NO:		
比例: SCALE:	日期: DATE:	